



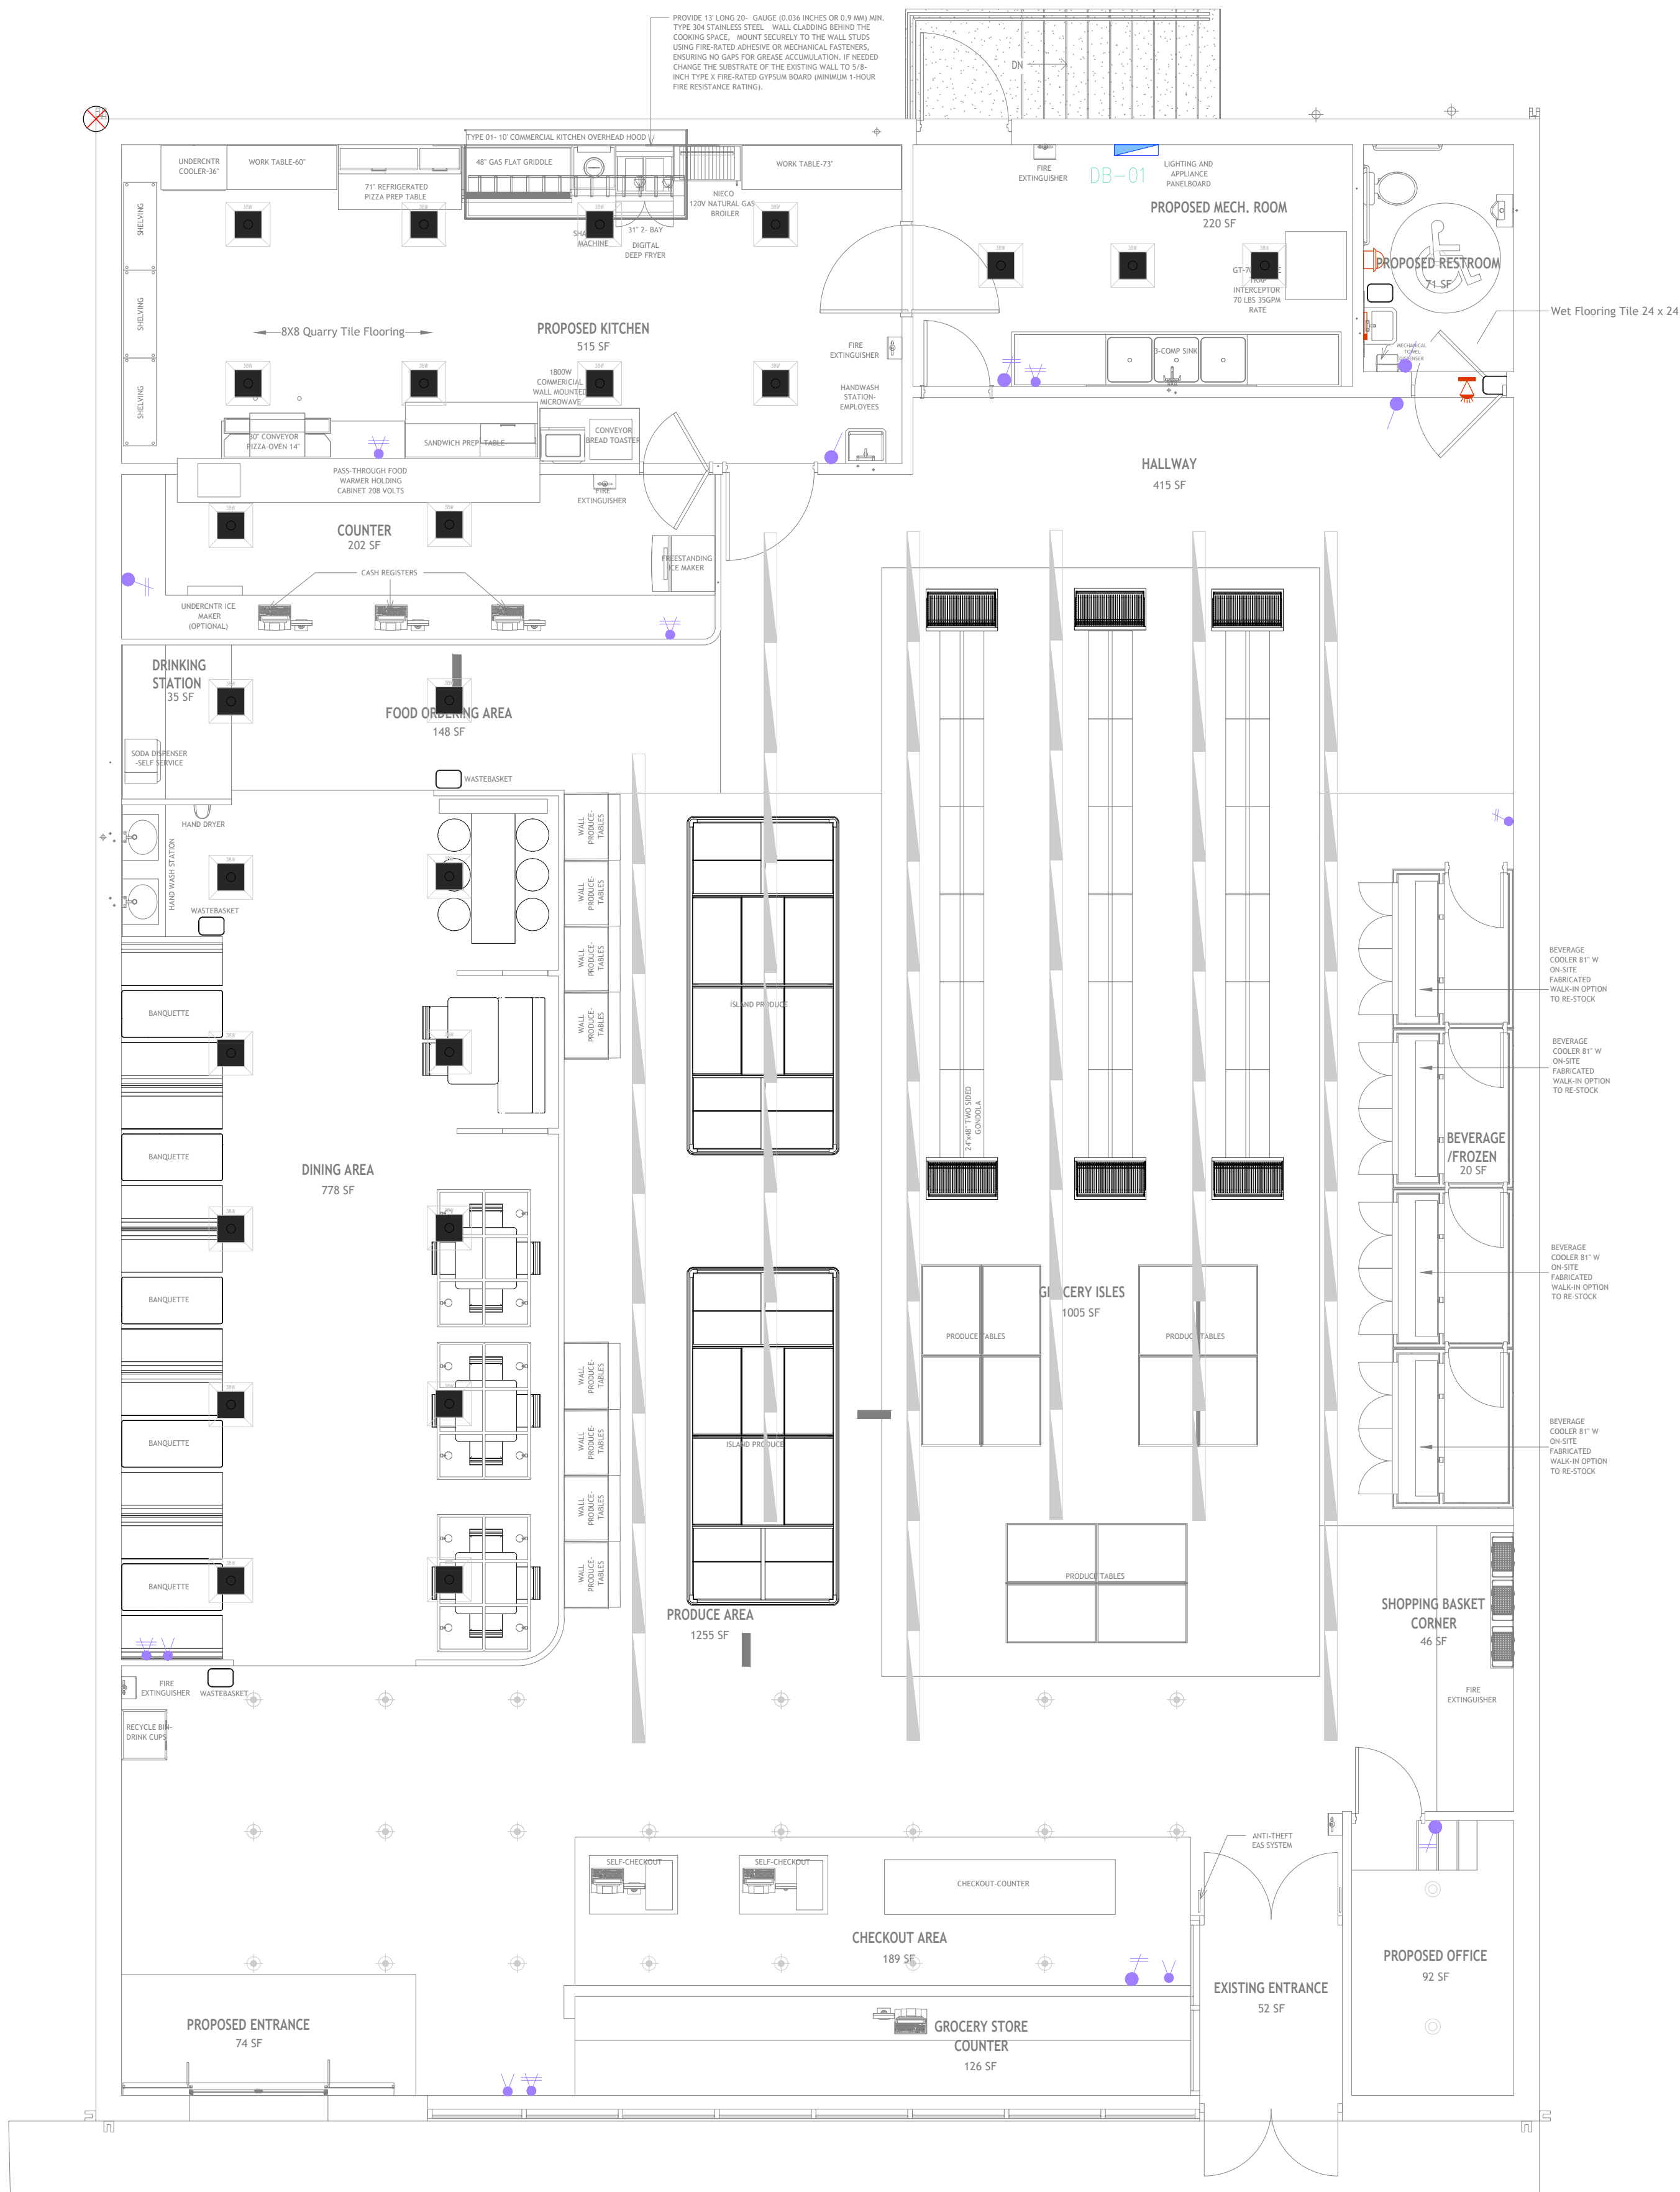

LIGHTING SYSTEM	
SYMBOL	DESCRIPTION
	ONE, TWO, THREE, AND FOUR GANG LIGHTING SWITCH
	ONE, TWO WAY GANG LIGHTING SWITCH
	17W RECESSED LED DOWNLIGHT
	56W LED LOW BAY LIGHT
	2' X 2' 38W RECESSED LED LIGHT
	5W MIRROR LIGHT
	50W WARNING LIGHT ON TOP ROOF-IP65
	PUSH BUTTON FOR EMERGENCY CALL IN TOILETS
	BUZZER AND LIGHT INDICATION FOR EMERGENCY CALL IN TOILETS
	25mm# MS CONDUIT RUN IN CEILING SLAB
	TWO SOCKETS
	BRACKET LIGHT
	FIXED TYPE DOME CAMERA
	DUPLEX 15A FLAT PIN SWITCH SOCKET OUTLET
	SPEAKER CEILING MOUNTED
	SMOKE DETECTOR
	HEAT DETECTOR
	PUBLIC ACCESS & VOICE EVACUATION SPEAKER 6W (CEILING MOUNTED)
	DISTRIBUTION BOARD (DB)



DESCRIPTION		REVISION NO. DATE
ADVANCE COPY		
PROJECT: GREENE GROCERY AND CAFE202 NORTH MAIN STREET GREENSBRO GA 30642		
OWNER NAME: FIROZALI MOMIN		
CONSULTANTS:		
TITLE: LIGHTING LAYOUT		
DESIGNED BY I.M	SCALE 3/32"=1'-0"	DATE MAY-2025
DRAWN BY I.M	JOB NO. 01	DRAWING NO. EL-01
CHECKED BY -	ORIGINAL SHT SIZE: A3	PLOTTED SHT SIZE: A3
APPROVED BY -	CAD FILE NAME: LIGHTING-4.dwg	

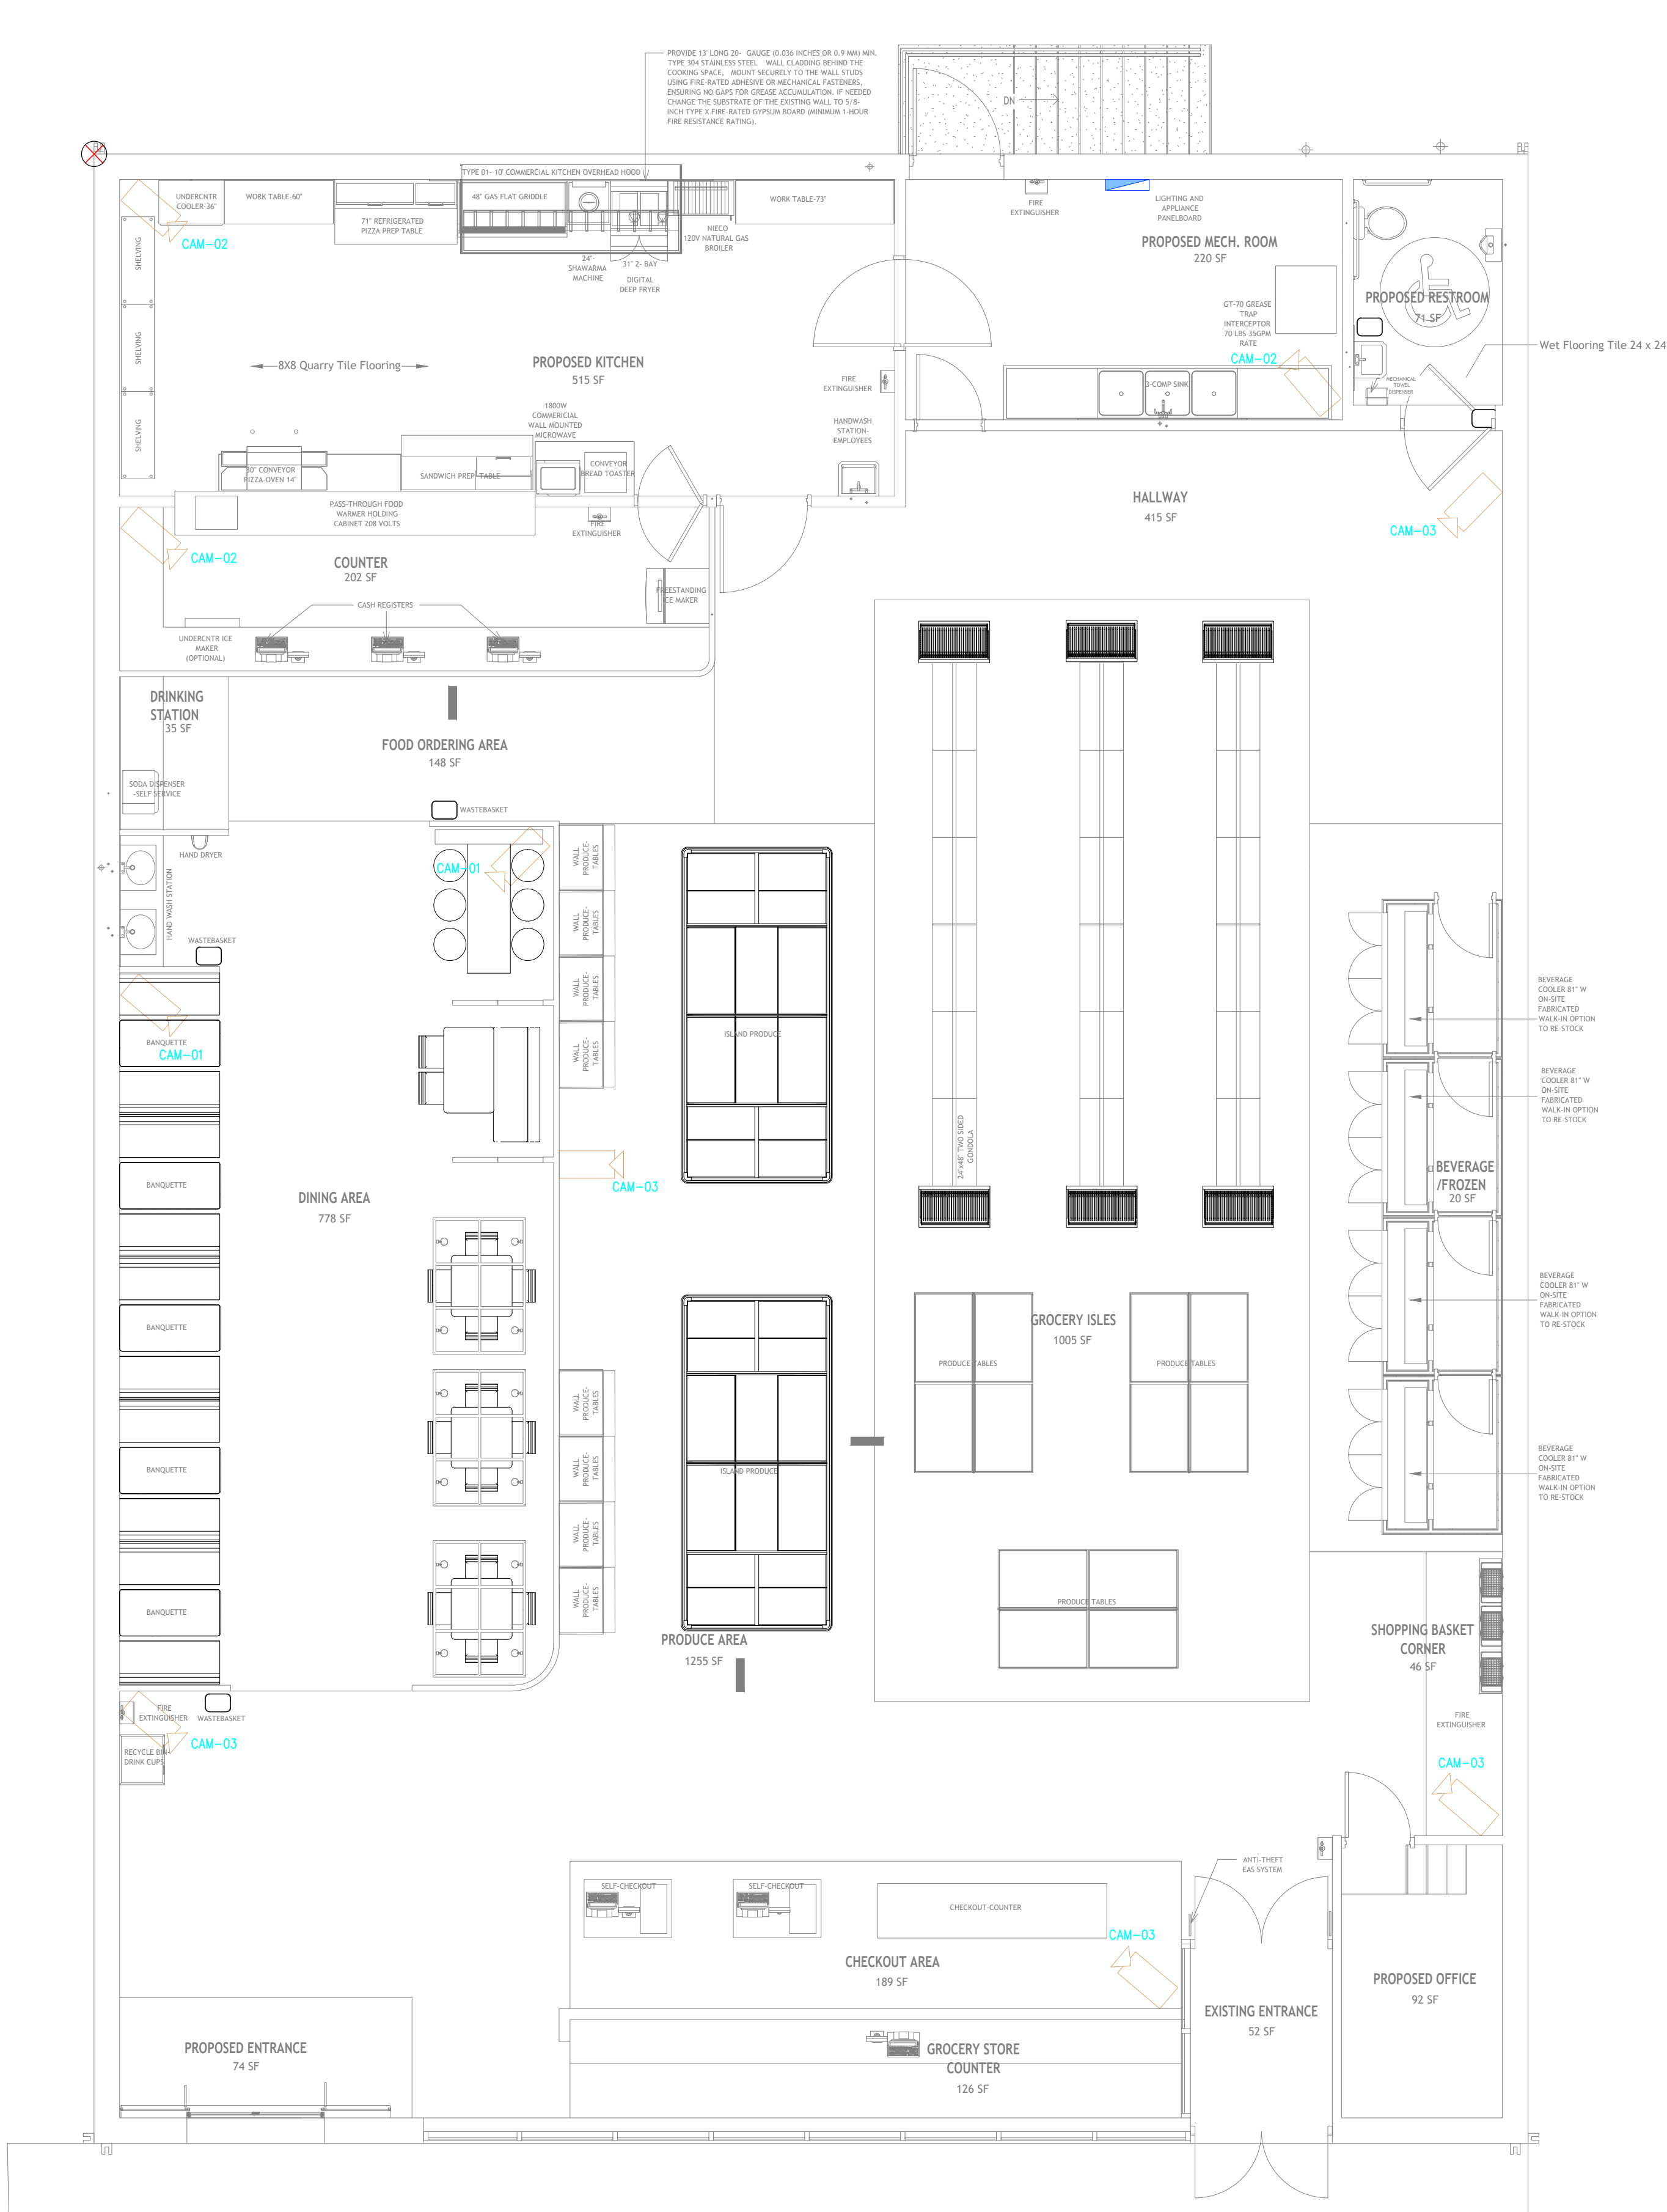

LIGHTING SYSTEM	
SYMBOL	DESCRIPTION
	ONE, TWO, THREE, AND FOUR GANG LIGHTING SWITCH
	ONE, TWO, WAY GANG LIGHTING SWITCH
	17W RECESSED LED DOWNLIGHT
	56W LED LOW BAY LIGHT
	2' X 2' 38W RECESSED LED LIGHT
	5W MIRROR LIGHT
	50W WARNING LIGHT ON TOP ROOF-IP65
	PUSH BUTTON FOR EMERGENCY CALL IN TOILETS
	BUZZER AND LIGHT INDICATION FOR EMERGENCY CALL IN TOILETS
	25mm# MS CONDUIT RUN IN CEILING SLAB
	TWO SOCKETS
	BRACKET LIGHT
	FIXED TYPE DOME CAMERA
	DUPLEX 13A FLAT PIN SWITCH SOCKET OUTLET
	SPEAKER CEILING MOUNTED
	SMOKE DETECTOR
	HEAT DETECTOR
	PUBLIC ACCESS & VOICE EVACUATION SPEAKER 6W (CEILING MOUNTED)
	DISTRIBUTION BOARD (DB)



DESCRIPTION	REVISION NO.
	DATE
ADVANCE COPY	

PROJECT:

GREENE GROCERY AND CAFE202 NORTH MAIN
STREET GREENSBRO GA 30642

OWNER NAME:


FIROZALI MOMIN

CONSULTANTS:

TITLE:

CCTV LAYOUT


DESIGNED BY I.M	SCALE 3/32"=1'-0"	DATE MAY-2025
DRAWN BY I.M	JOB NO. 01	DRAWING NO. EL-02
CHECKED BY -	ORIGINAL SHT SIZE: A3	PLOTTED SHT SIZE: A3
APPROVED BY -	CAD FILE NAME: LIGHTING-4.dwg	

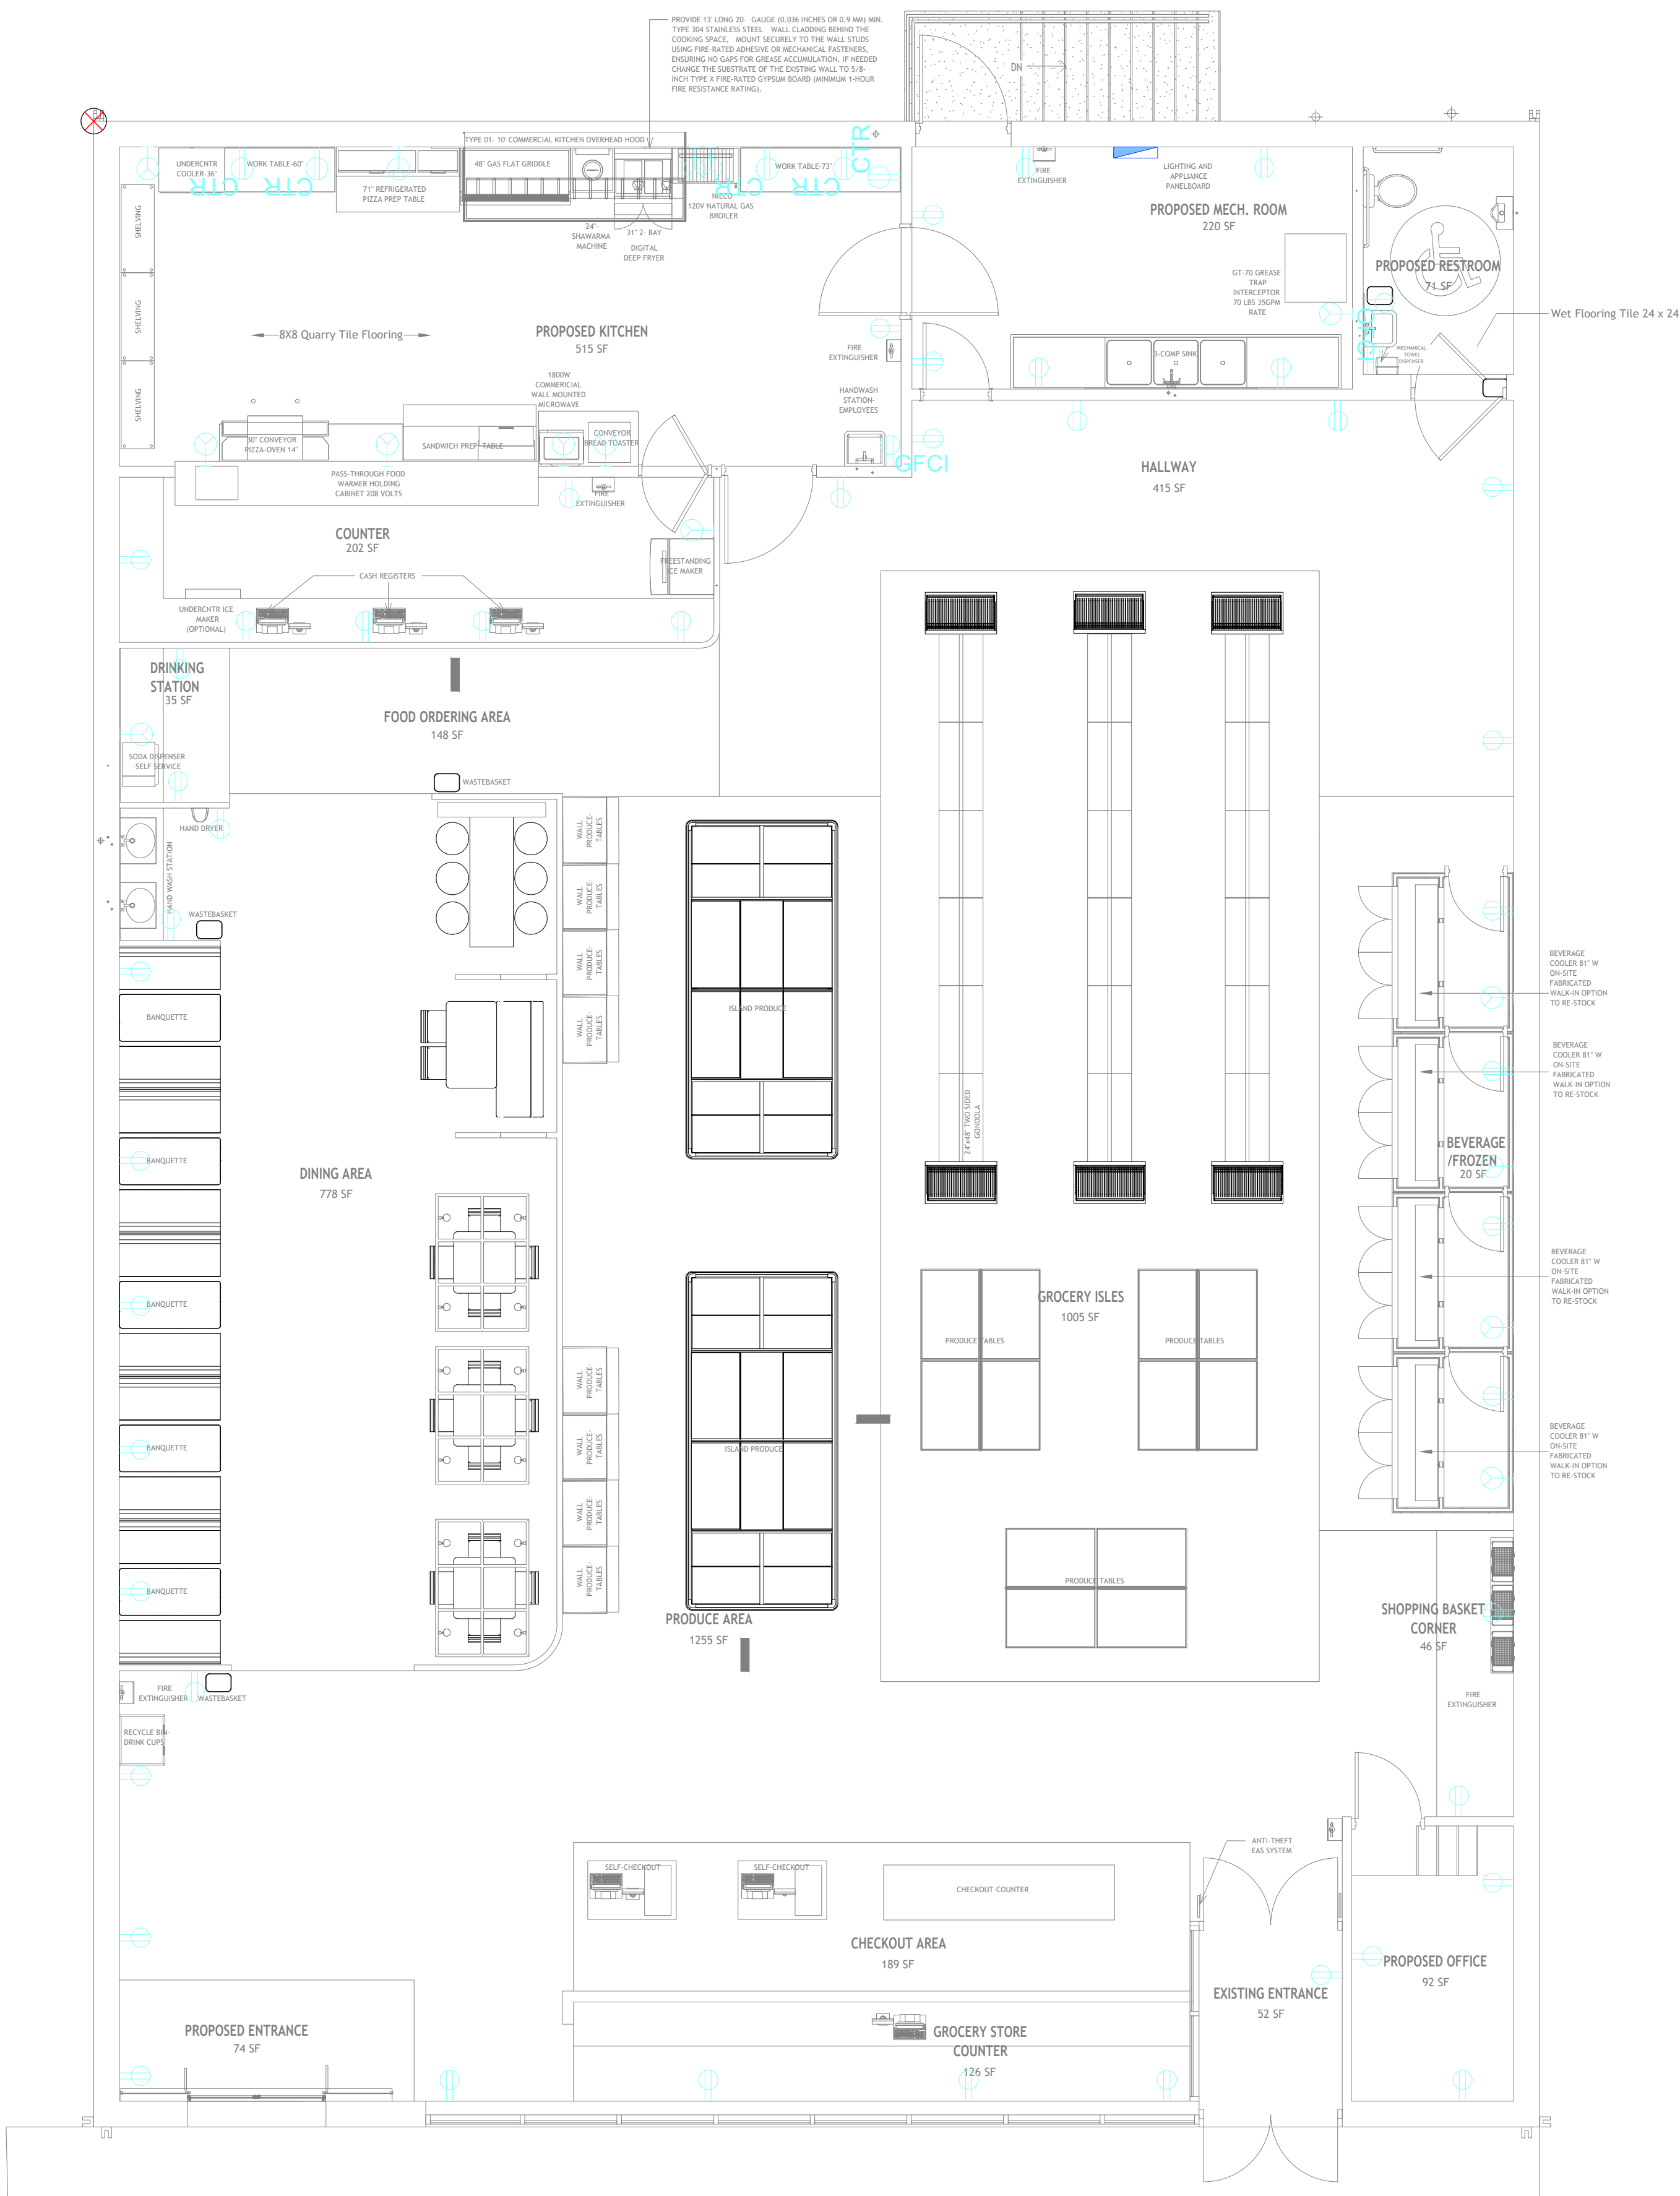

LIGHTING SYSTEM	
SYMBOL	DESCRIPTION
	ONE, TWO, THREE, AND FOUR GANG LIGHTING SWITCH
	ONE, TWO WAY GANG LIGHTING SWITCH
	17W RECESSED LED DOWNLIGHT
	50W LED LOW BAY LIGHT
	2' X 2' 30W RECESSED LED LIGHT
	5W MIRROR LIGHT
	50W WARNING LIGHT ON TOP ROOF-IP65
	PUSH BUTTON FOR EMERGENCY CALL IN TOILETS
	BUZZER AND LIGHT INDICATION FOR EMERGENCY CALL IN TOILETS
	25mm MS CONDUIT RUN IN CEILING SLAB
	TWO SOCKETS
	BRACKET LIGHT
	FIXED TYPE DOME CAMERA
	DUPLEX 15A FLAT PIN SWITCH SOCKET OUTLET
	SPEAKER CEILING MOUNTED
	SMOKE DETECTOR
	HEAT DETECTOR
	PUBLIC ACCESS & VOICE EVACUATION SPEAKER 6W (CEILING MOUNTED)
	DISTRIBUTION BOARD (DB)




DESCRIPTION		REVISION NO. DATE
ADVANCE COPY		
PROJECT: GREENE GROCERY AND CAFE202 NORTH MAIN STREET GREENSBRO GA 30642		
OWNER NAME: FIROZALI MOMIN		
CONSULTANTS:		
TITLE: POWER LAYOUT		
DESIGNED BY I.M	SCALE 3/32"=1'-0"	DATE MAY-2025
DRAWN BY I.M	JOB NO. 01	DRAWING NO. EL-03
CHECKED BY -	ORIGINAL SHT SIZE: A3	PLOTTED SHT SIZE: A3
APPROVED BY -	CAD FILE NAME: LIGHTING-4.dwg	

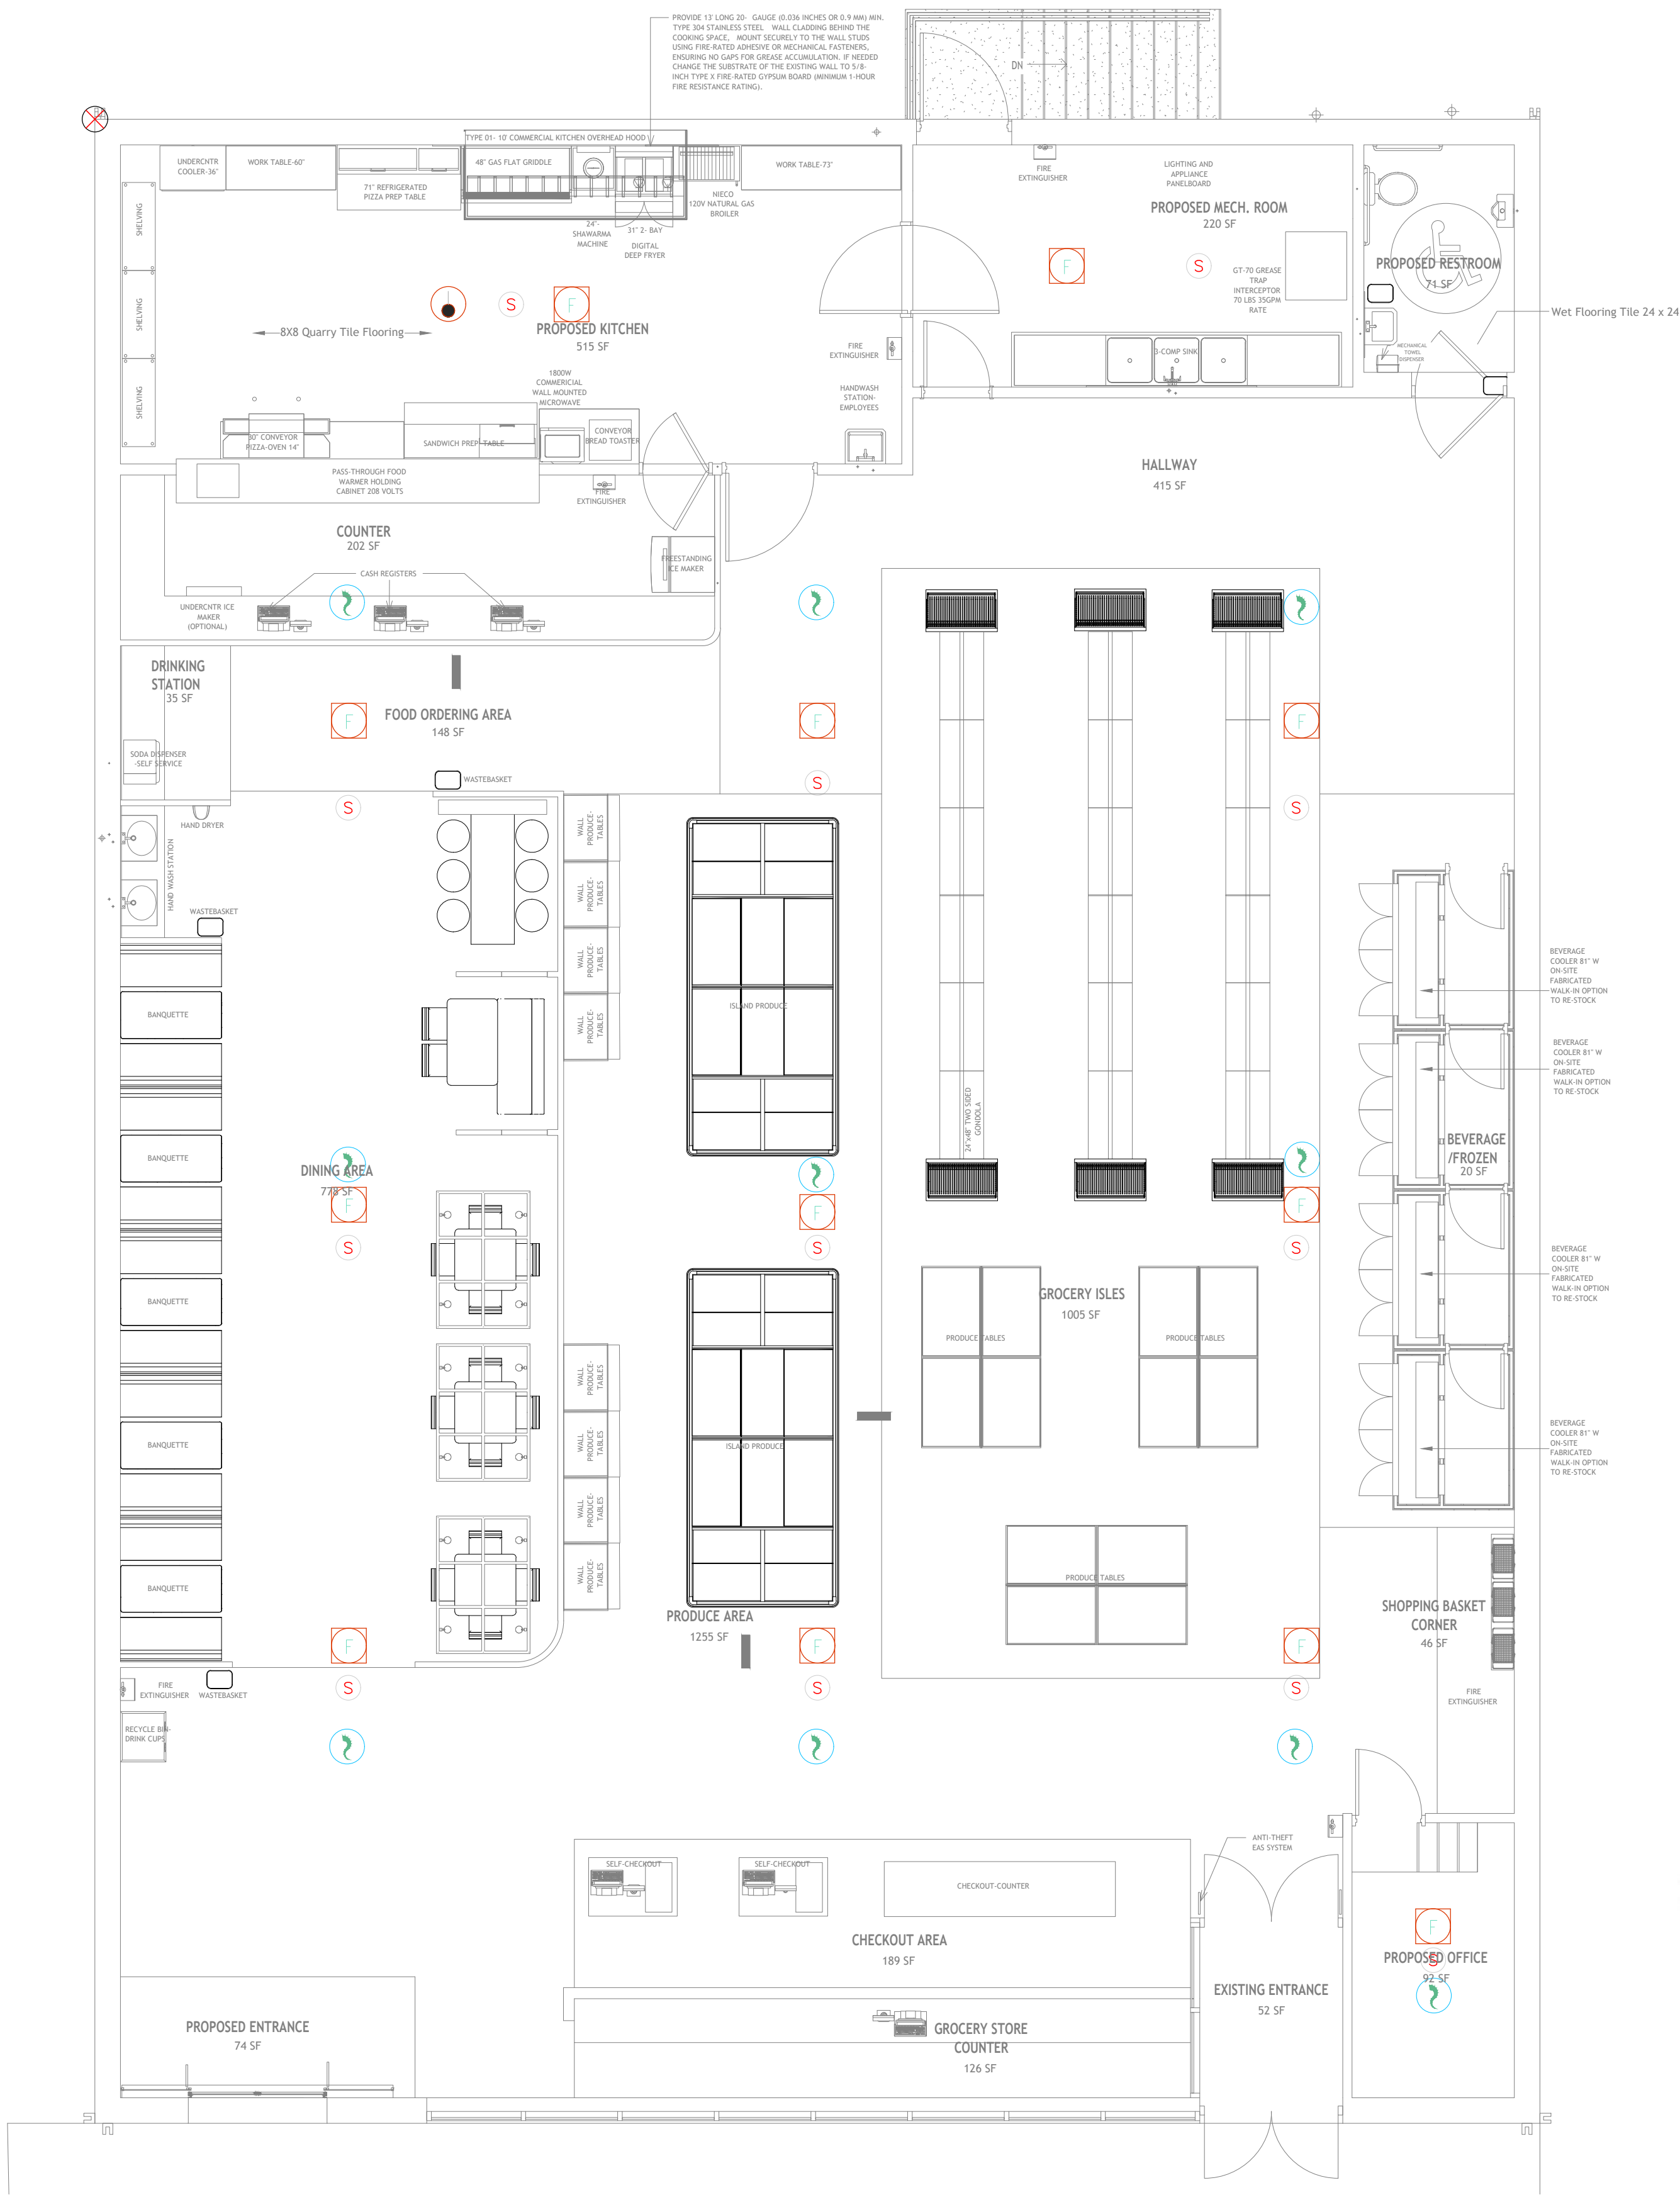

LIGHTING SYSTEM	
SYMBOL	DESCRIPTION
	ONE, TWO, THREE, AND FOUR GANG LIGHTING SWITCH
	ONE, TWO WAY GANG LIGHTING SWITCH
	17W RECESSED LED DOWNLIGHT
	56W LED LOW BAY LIGHT
	2' X 2' 38W RECESSED LED LIGHT
	5W MIRROR LIGHT
	50W WARNING LIGHT ON TOP ROOF-IP65
	PUSH BUTTON FOR EMERGENCY CALL IN TOILETS
	BUZZER AND LIGHT INDICATION FOR EMERGENCY CALL IN TOILETS
	25mm MS CONDUIT RUN IN CEILING SLAB
	TWO SOCKETS
	BRACKET LIGHT
	FIXED TYPE DOME CAMERA
	DUPLEX 13A FLAT PIN SWITCH SOCKET OUTLET
	SPEAKER CEILING MOUNTED
	SMOKE DETECTOR
	HEAT DETECTOR
	PUBLIC ACCESS & VOICE EVACUATION SPEAKER 8W (CEILING MOUNTED)
	DISTRIBUTION BOARD (DB)



DESCRIPTION		REVISION NO. DATE
ADVANCE COPY		
PROJECT:		
GREENE GROCERY AND CAFE202 NORTH MAIN STREET GREENSBRO GA 30642		
OWNER NAME:		
FIROZALI MOMIN		
CONSULTANTS:		
TITLE:		
FIRE ALARM LAYOUT		
DESIGNED BY I.M	SCALE 3/32"=1'-0"	DATE MAY-2025
DRAWN BY I.M	JOB NO. 01	DRAWING NO. EL-04
CHECKED BY -	ORIGINAL SHT SIZE: A3	PLOTTED SHT SIZE: A3
APPROVED BY -	CAD FILE NAME: LIGHTING-4.dwg	

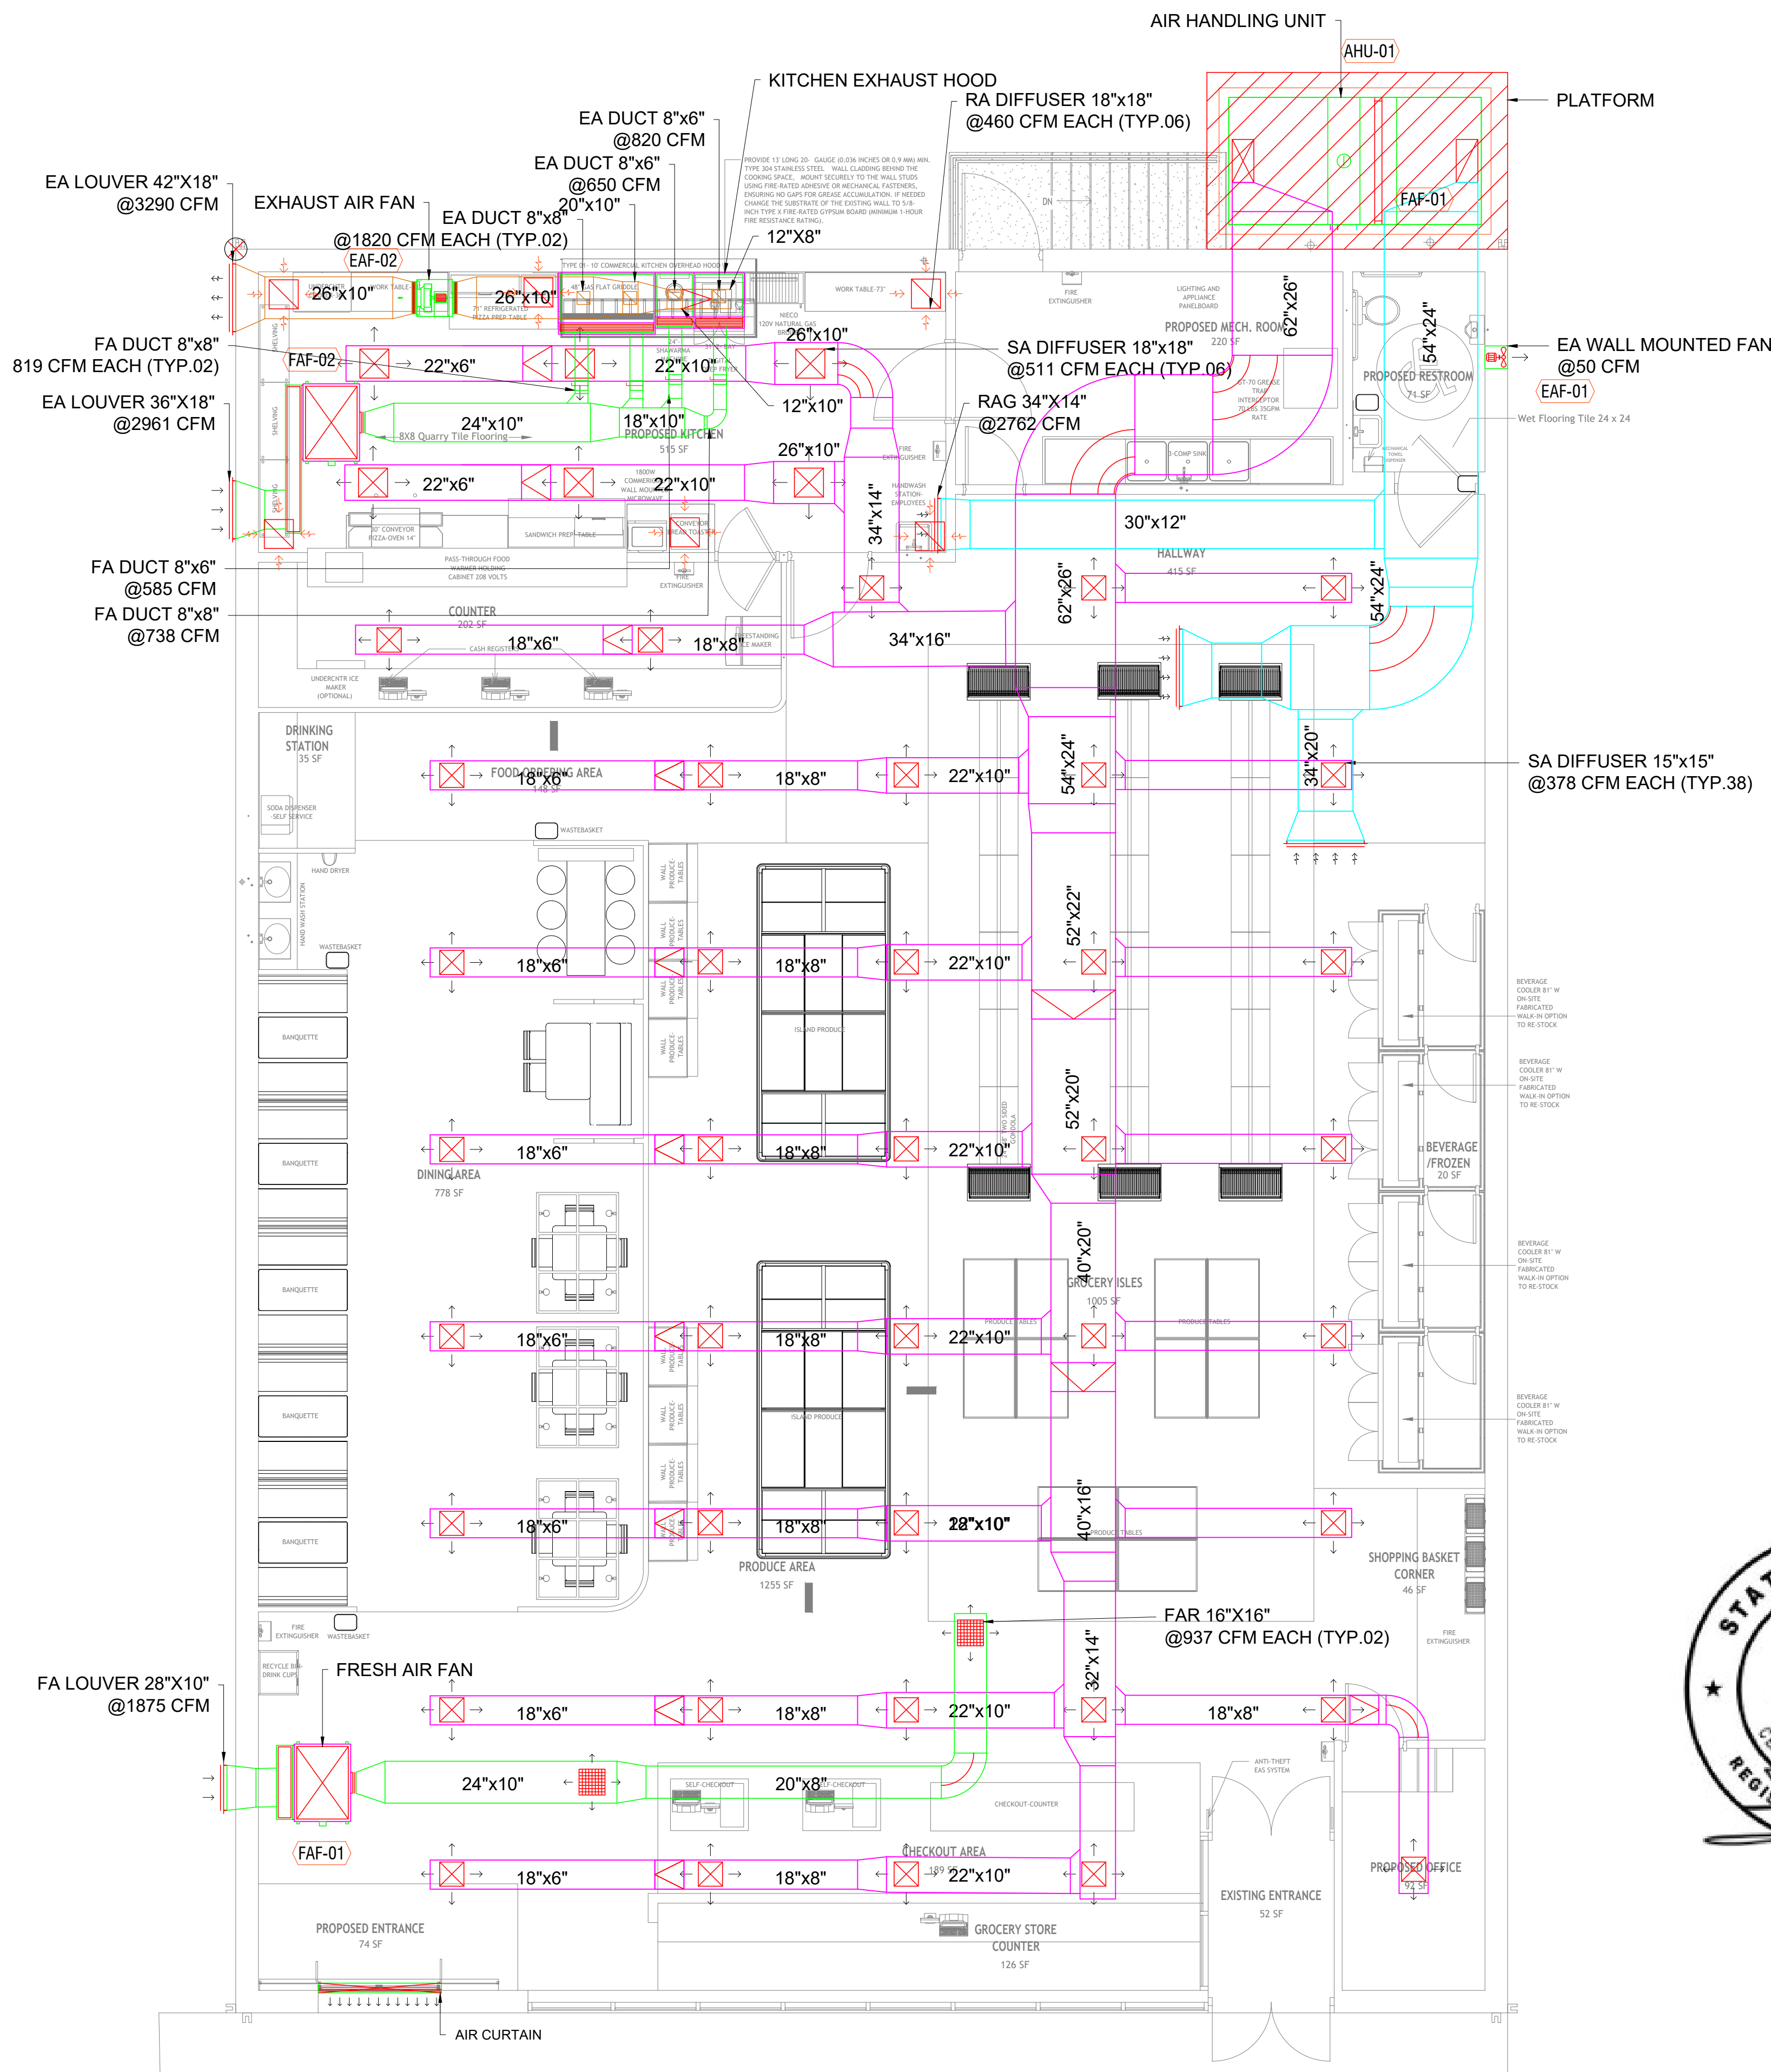


LEGENDS:	
	SUPPLY AIR DUCT
	RETURN AIR DUCT
	FRESH AIR DUCT
	EXHAUST AIR DUCT
	SUPPLY AIR DIFFUSER
	RETURN AIR DIFFUSER
	EXHAUST AIR LOUVER
	FRESH AIR LOUVER
	FRESH AIR REGISTER
	RETURN AIR GRILLE
	EXHAUST WALL MOUNTED FAN
	VOLUME CONTROL DAMPER
	KITCHEN EXHAUST HOOD
	EXHAUST IN LINE FAN
	FRESH AIR FAN
	AIR CURTAIN
	AIR HANDLING UNIT



DESCRIPTION		REVISION NO.	DATE
ADVANCE COPY			
PROJECT: GREENE GROCERY AND CAFE202 NORTH MAIN STREET GREENSBRO GA 30642			
OWNER NAME: FIROZALI MOMIN			
CONSULTANTS:			
TITLE: AIR CONDITIONING & MECHANICAL VENTILATION LAYOUT			
DESIGNED BY	I.M	SCALE	3/32"=1'-0"
DRAWN BY	I.M	JOB NO.	01
CHECKED BY	-	ORIGINAL SHT SIZE:	A3
APPROVED BY	-	CAD FILE NAME:	LIGHTING-4.dwg
		DATE	MAY-2025
		DRAWING NO.	ACMV-02
		PLOTTED SHT SIZE:	A3

OPTION -02

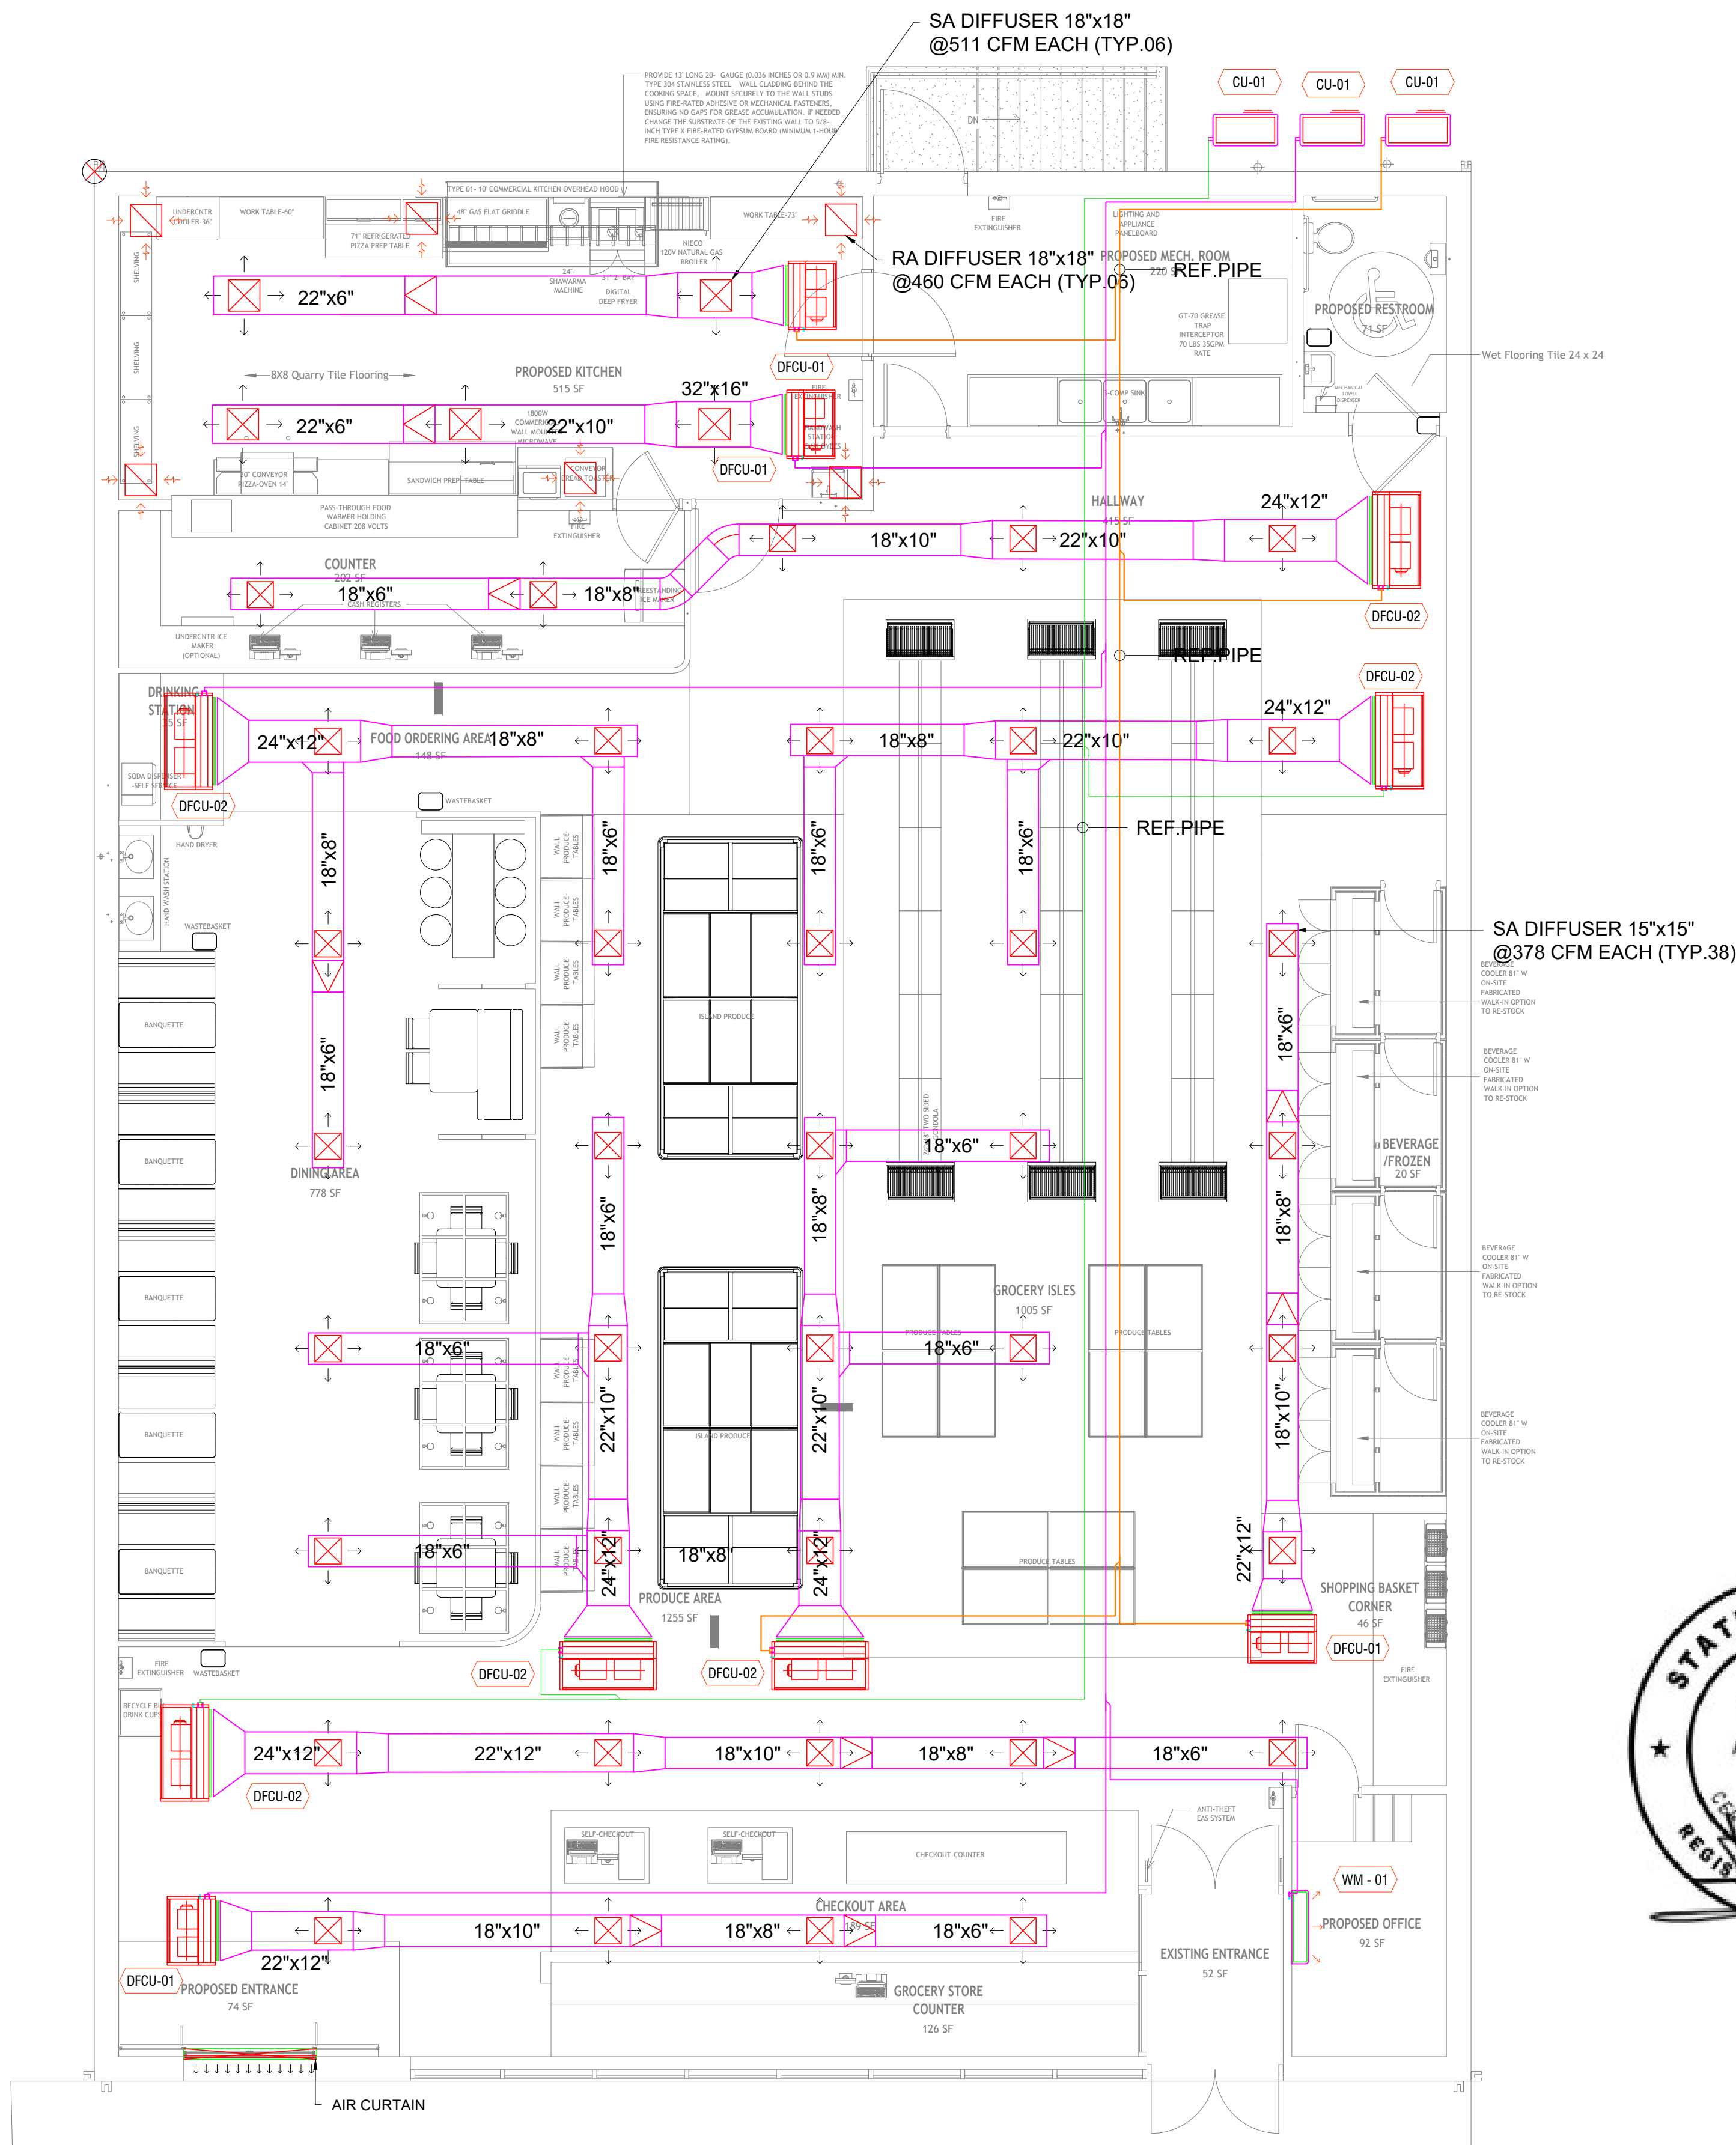

LEGENDS:

	SUPPLY AIR DUCT
	RETURN AIR DUCT
	FRESH AIR DUCT
	EXHAUST AIR DUCT
	REFRIGERANT PIPE
	DRAIN PIPE
	SUPPLY AIR DIFFUSER
	RETURN AIR DIFFUSER
	EXHAUST AIR LOUVER
	FRESH AIR LOUVER
	FRESH AIR REGISTER
	EXHAUST WALL MOUNTED FAN
	VOLUME CONTROL DAMPER
	DUCTED FAN COIL UNIT
	KITCHEN EXHAUST HOOD
	EXHAUST IN LINE FAN
	FRESH AIR FAN
	AIR CURTAIN
	CONDENSING UNIT



DESCRIPTION	REVISION NO.	DATE
ADVANCE COPY		


PROJECT:
GREENE GROCERY AND CAFE202 NORTH MAIN STREET GREENSBRO GA 30642

OWNER NAME:
FIROZALI MOMIN

CONSULTANTS:

TITLE:
AIR CONDITIONING LAYOUT


DESIGNED BY I.M	SCALE 3/32"=1'-0"	DATE MAY-2025
DRAWN BY I.M	JOB NO. 01	DRAWING NO. AC-02
CHECKED BY -	ORIGINAL SHT SIZE: A3	PLOTTED SHT SIZE: A3
APPROVED BY -	CAD FILE NAME: LIGHTING-4.dwg	

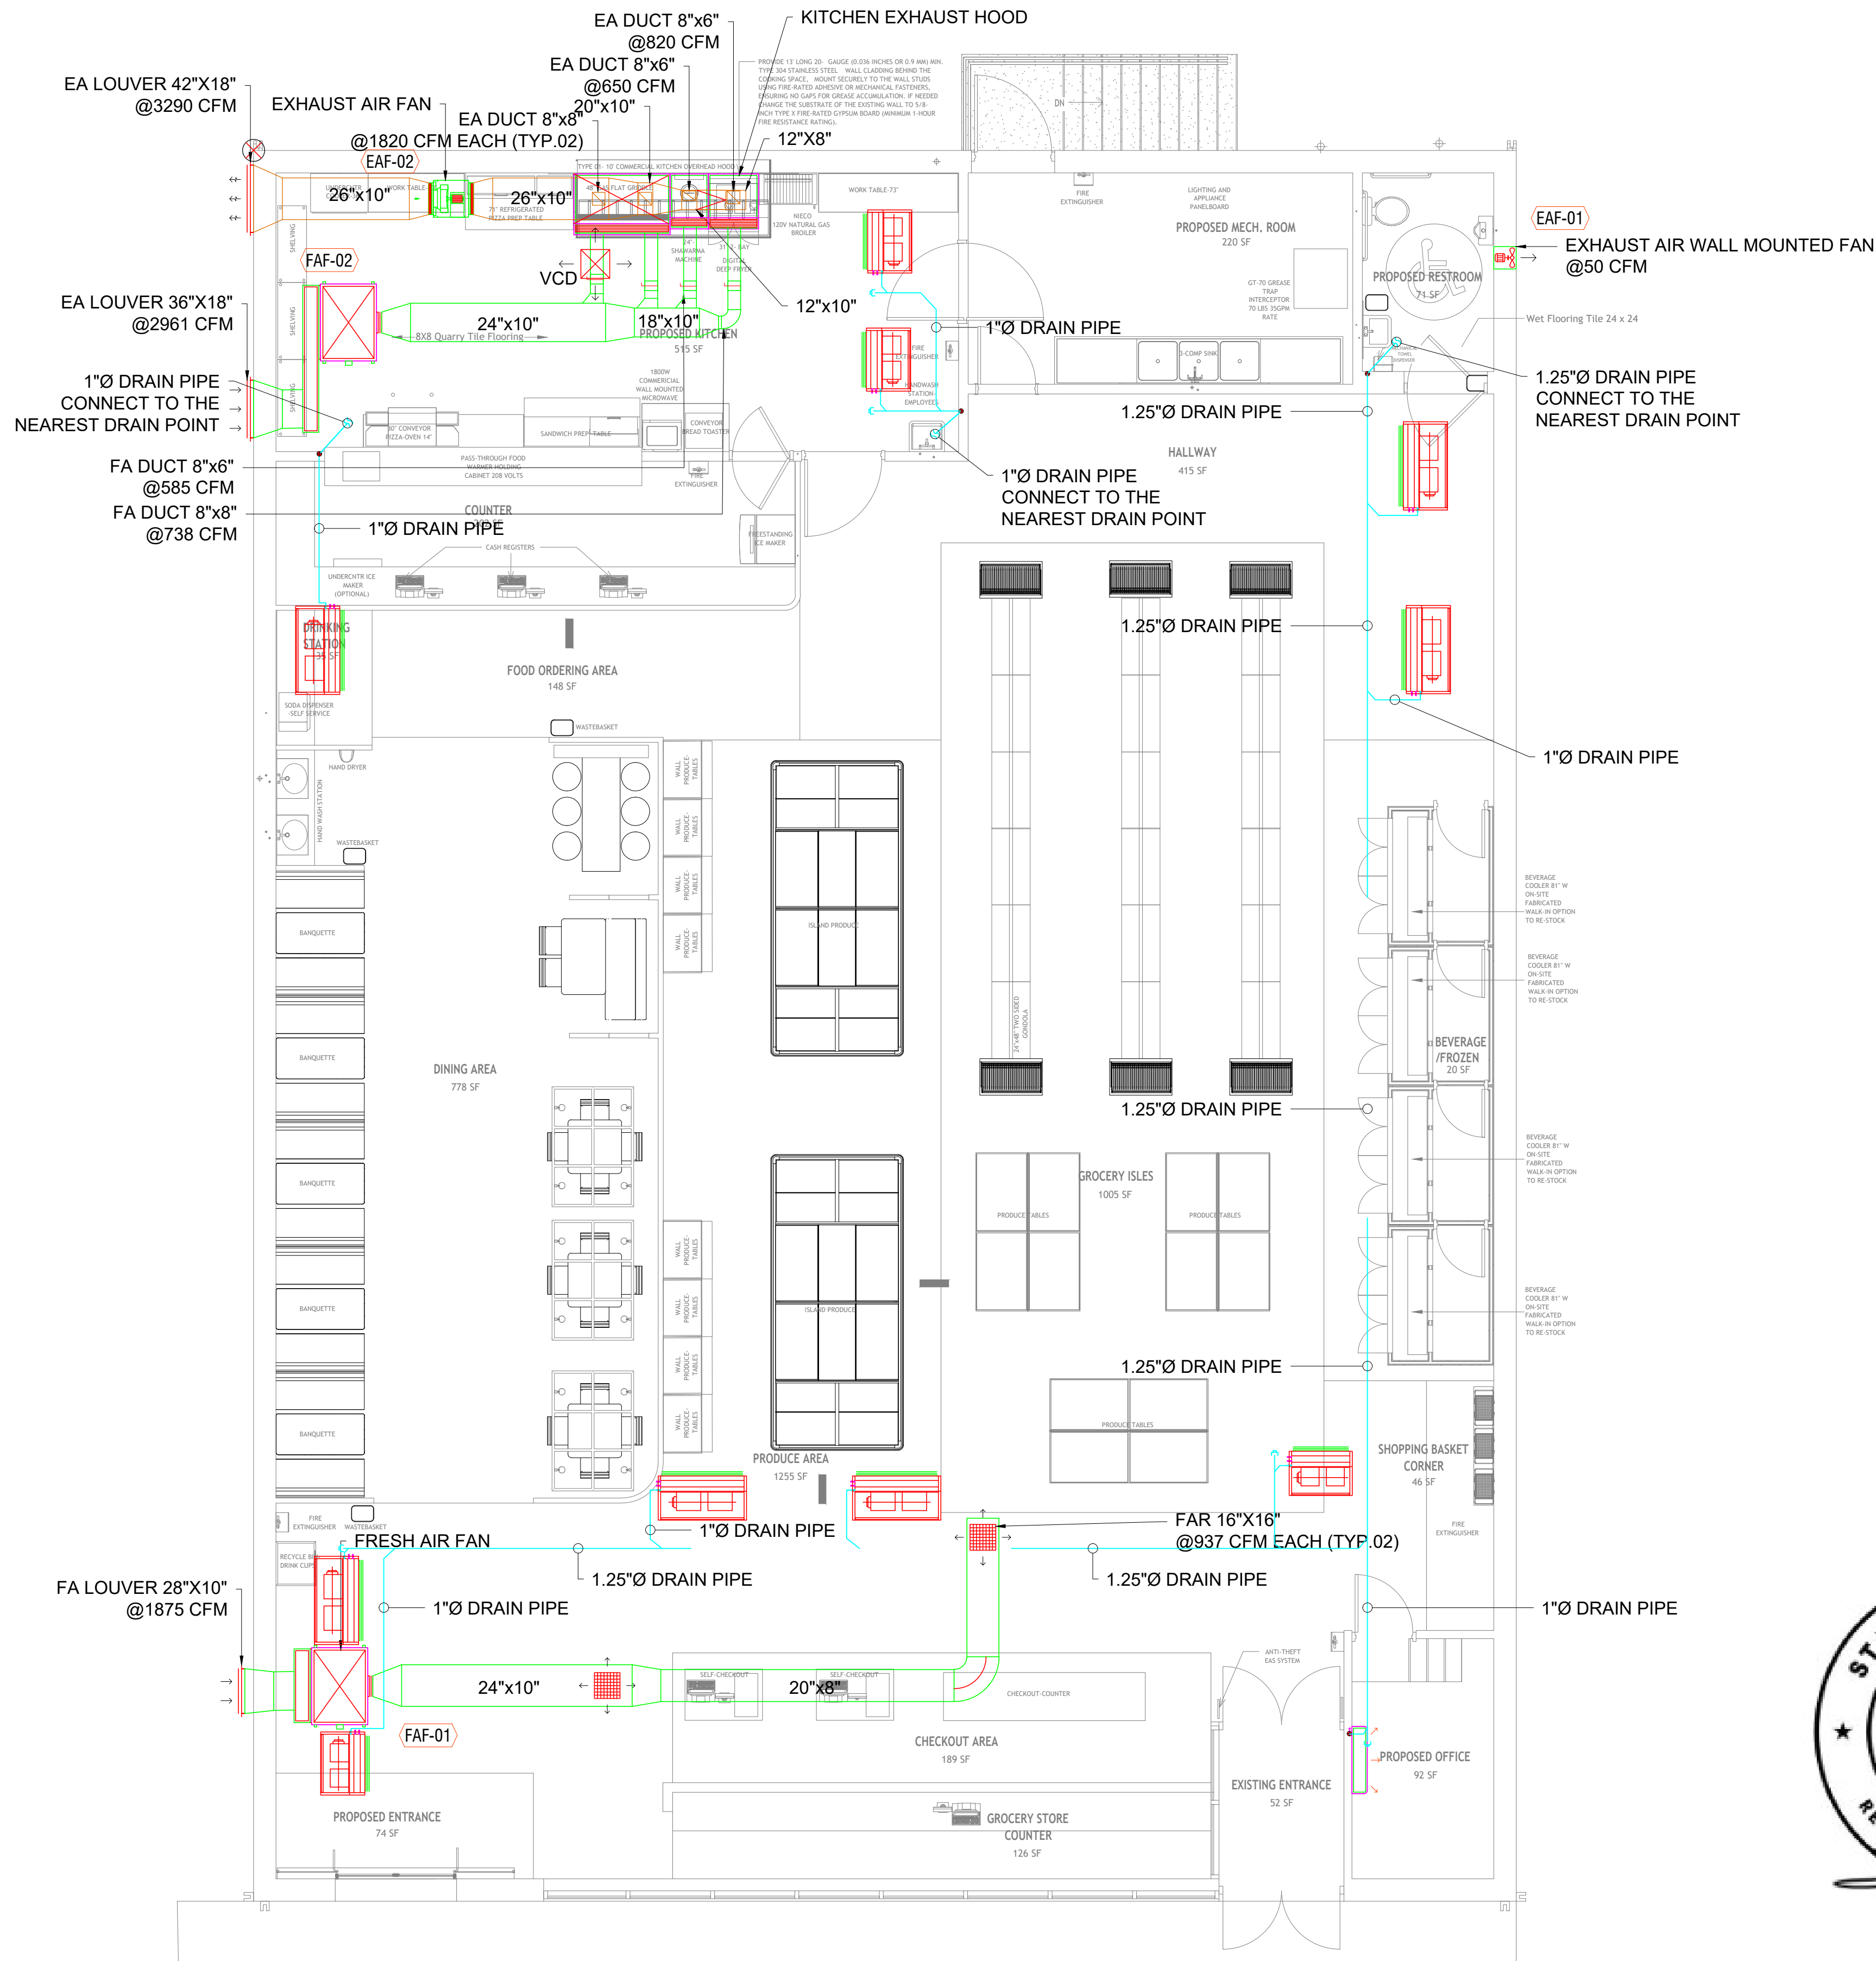

LEGENDS:	
	SUPPLY AIR DUCT
	RETURN AIR DUCT
	FRESH AIR DUCT
	EXHAUST AIR DUCT
	REFRIGERANT PIPE
	DRAIN PIPE
	SUPPLY AIR DIFFUSER
	RETURN AIR DIFFUSER
	EXHAUST AIR LOUVER
	FRESH AIR LOUVER
	FRESH AIR REGISTER
	EXHAUST WALL MOUNTED FAN
	VOLUME CONTROL DAMPER
	DUCTED FAN COIL UNIT
	KITCHEN EXHAUST HOOD
	EXHAUST IN LINE FAN
	FRESH AIR FAN
	AIR CURTAIN
	CONDENSING UNIT



DESCRIPTION		REVISION NO.	DATE
ADVANCE COPY			
PROJECT: GREENE GROCERY AND CAFE202 NORTH MAIN STREET GREENSBRO GA 30642			
OWNER NAME: FIROZALI MOMIN			
CONSULTANTS:			
TITLE: MECHANICAL VENTILATION LAYOUT			
DESIGNED BY I.M		SCALE 3/32"=1'-0"	DATE MAY-2025
DRAWN BY I.M		JOB NO. 01	DRAWING NO. MV-02
CHECKED BY -		ORIGINAL SHT SIZE: A3	PLOTTED SHT SIZE: A3
APPROVED BY -		CAD FILE NAME: LIGHTING-4.dwg	

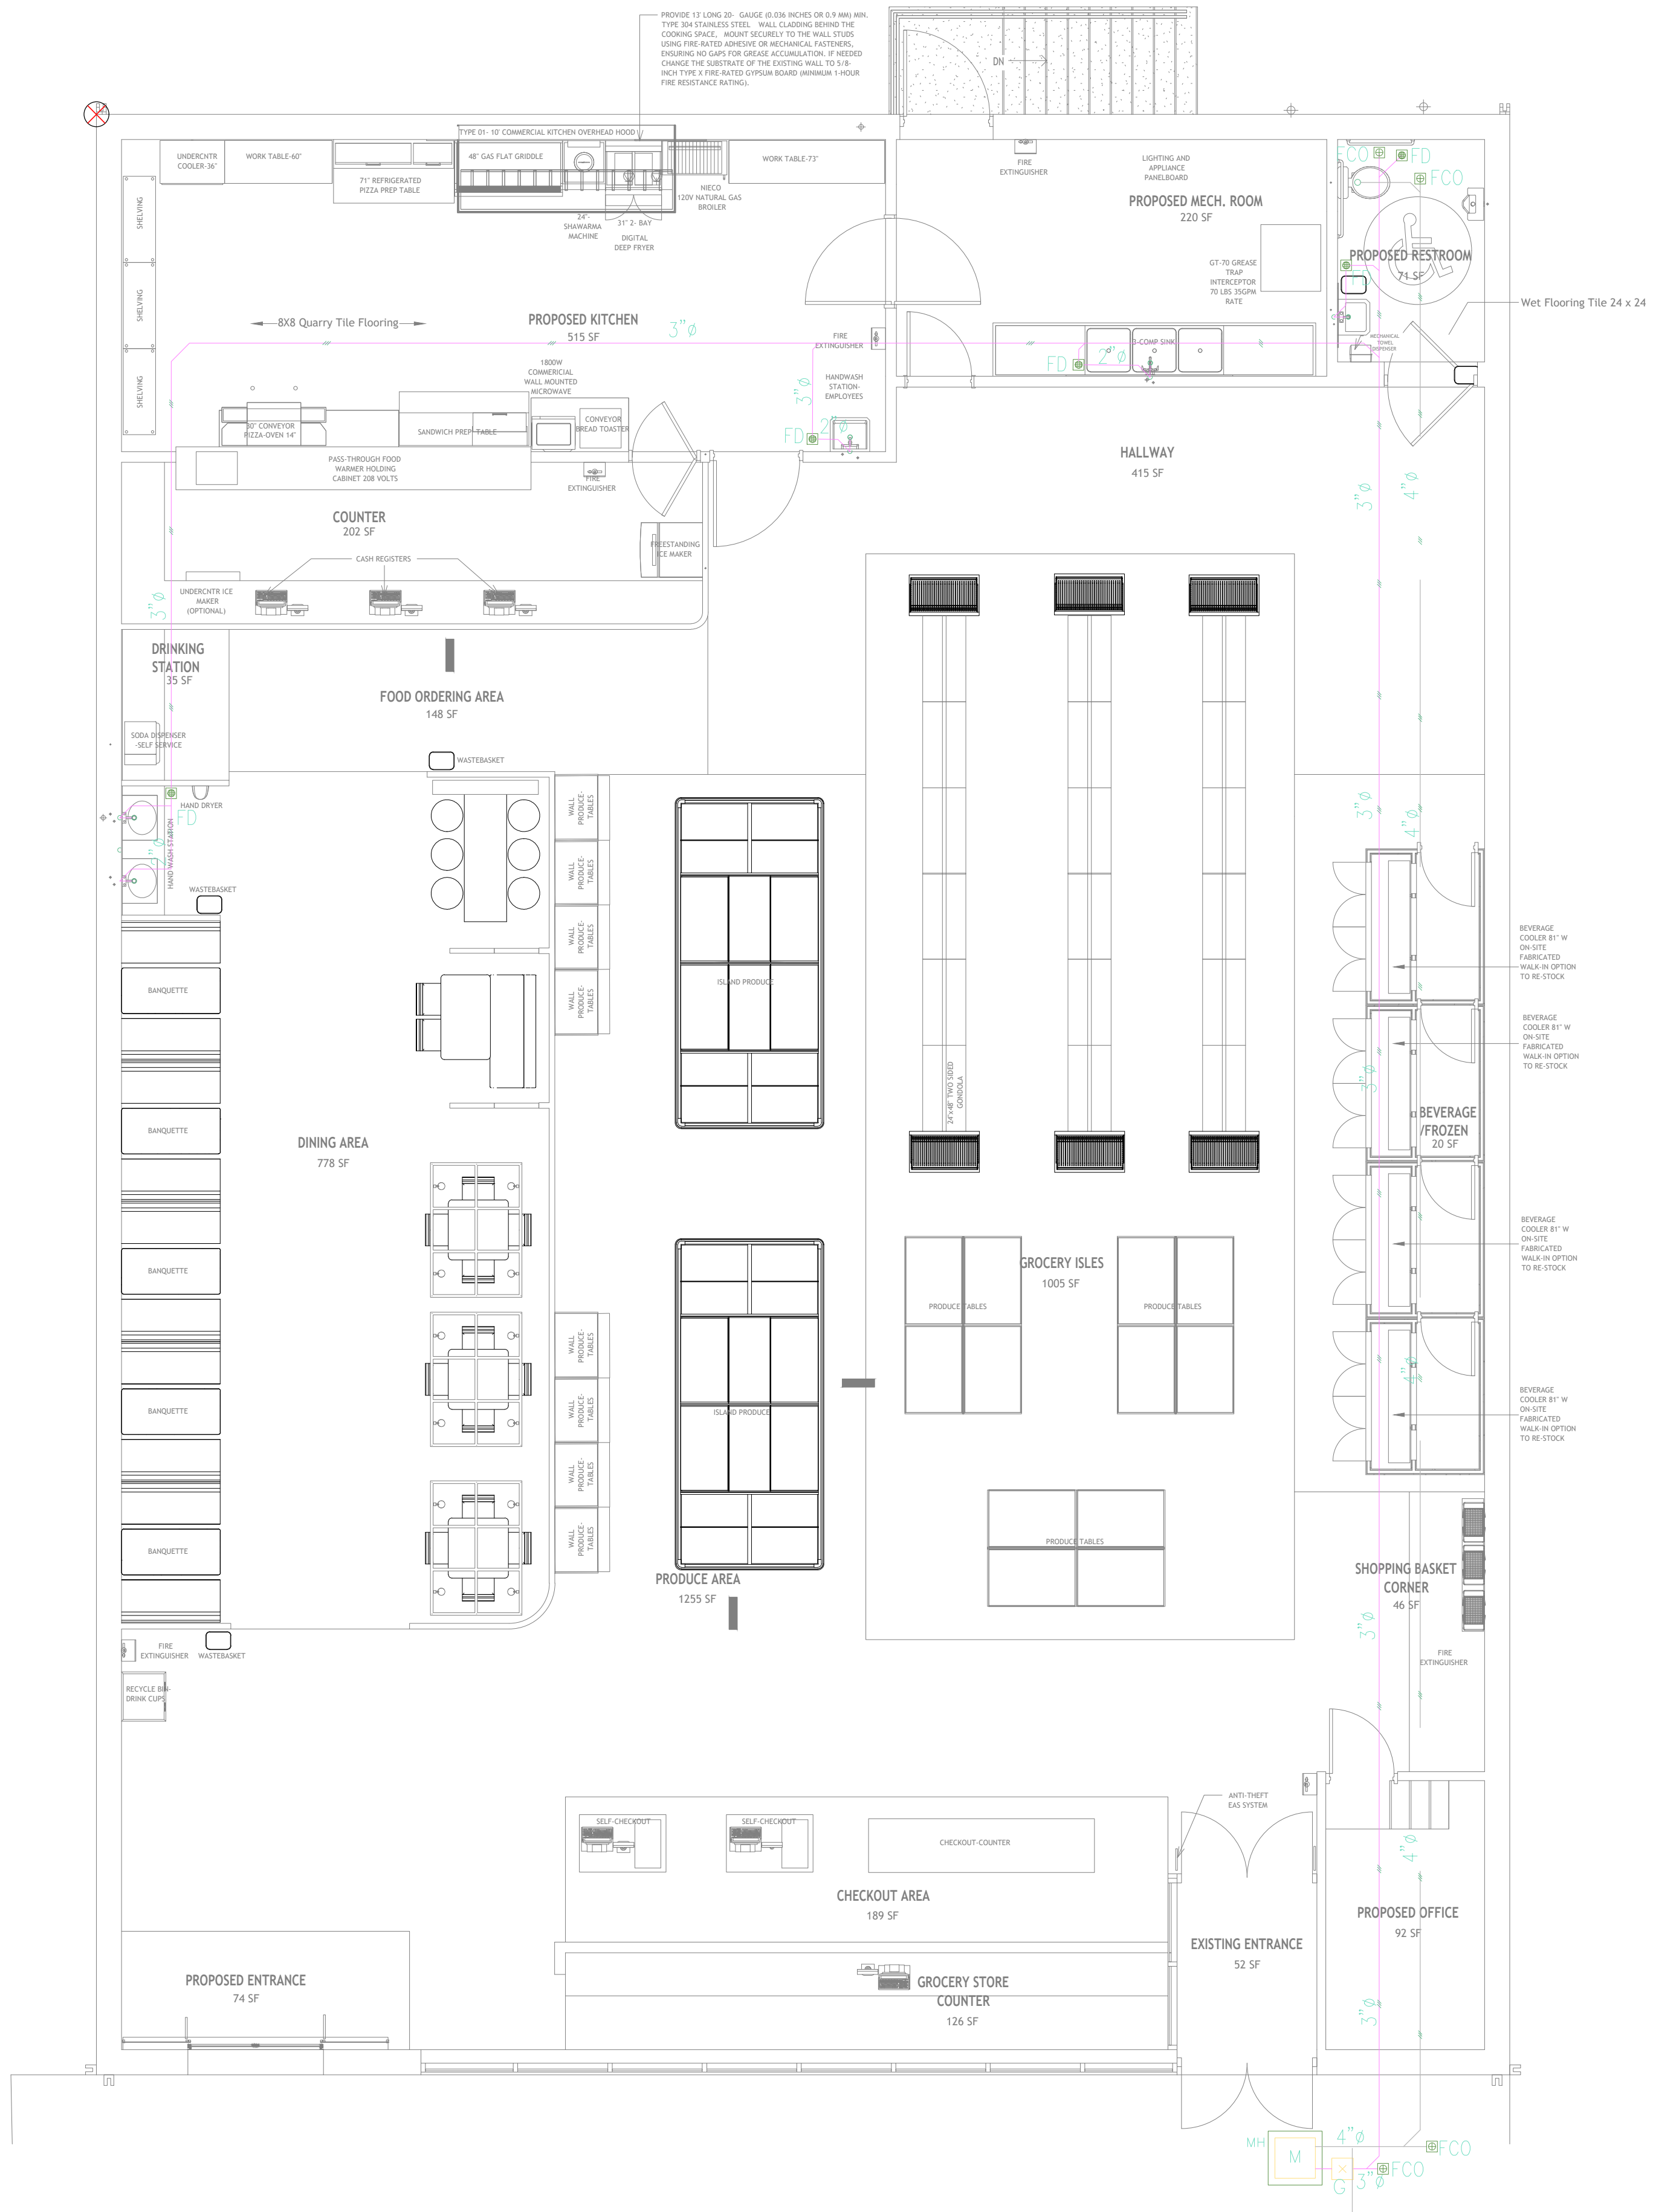


ABBREVIATIONS PLUMBING LEGEND

SYMBOL	DESCRIPTION
FD	FLOOR DRAIN
COP	CLEAN OUT PLUG
MH	MANHOLE
---	WASTE PIPE
---	SOIL PIPE
---	WASTE PIPE (BURIED)
---	PIPE UP
---	WASTE PIPE BREAK
---	SOIL PIPE BREAK
---	CLEAN OUT PLUG
---	FLOOR CLEAN OUT
---	SITE MAN HOLE
---	COLD WATER
---	HOT WATER



DESCRIPTION			REVISION NO.	DATE
ADVANCE COPY				
PROJECT:				
GREENE GROCERY AND CAFE202 NORTH MAIN STREET GREENSBRO GA 30642				
OWNER NAME:				
FIROZALI MOMIN				
CONSULTANTS:				
TITLE:				
DRAINAGE LAYOUT				
DESIGNED BY	SCALE	DATE		
I.M	3/32"=1'-0"	MAY-2025		
DRAWN BY	JOB NO.	DRAWING NO.		
I.M	01	DR-01		
CHECKED BY	ORIGINAL SHT SIZE:	PLOTTED SHT SIZE:		
-	A3	A3		
APPROVED BY	CAD FILE NAME:			
-	LIGHTING-4.dwg			

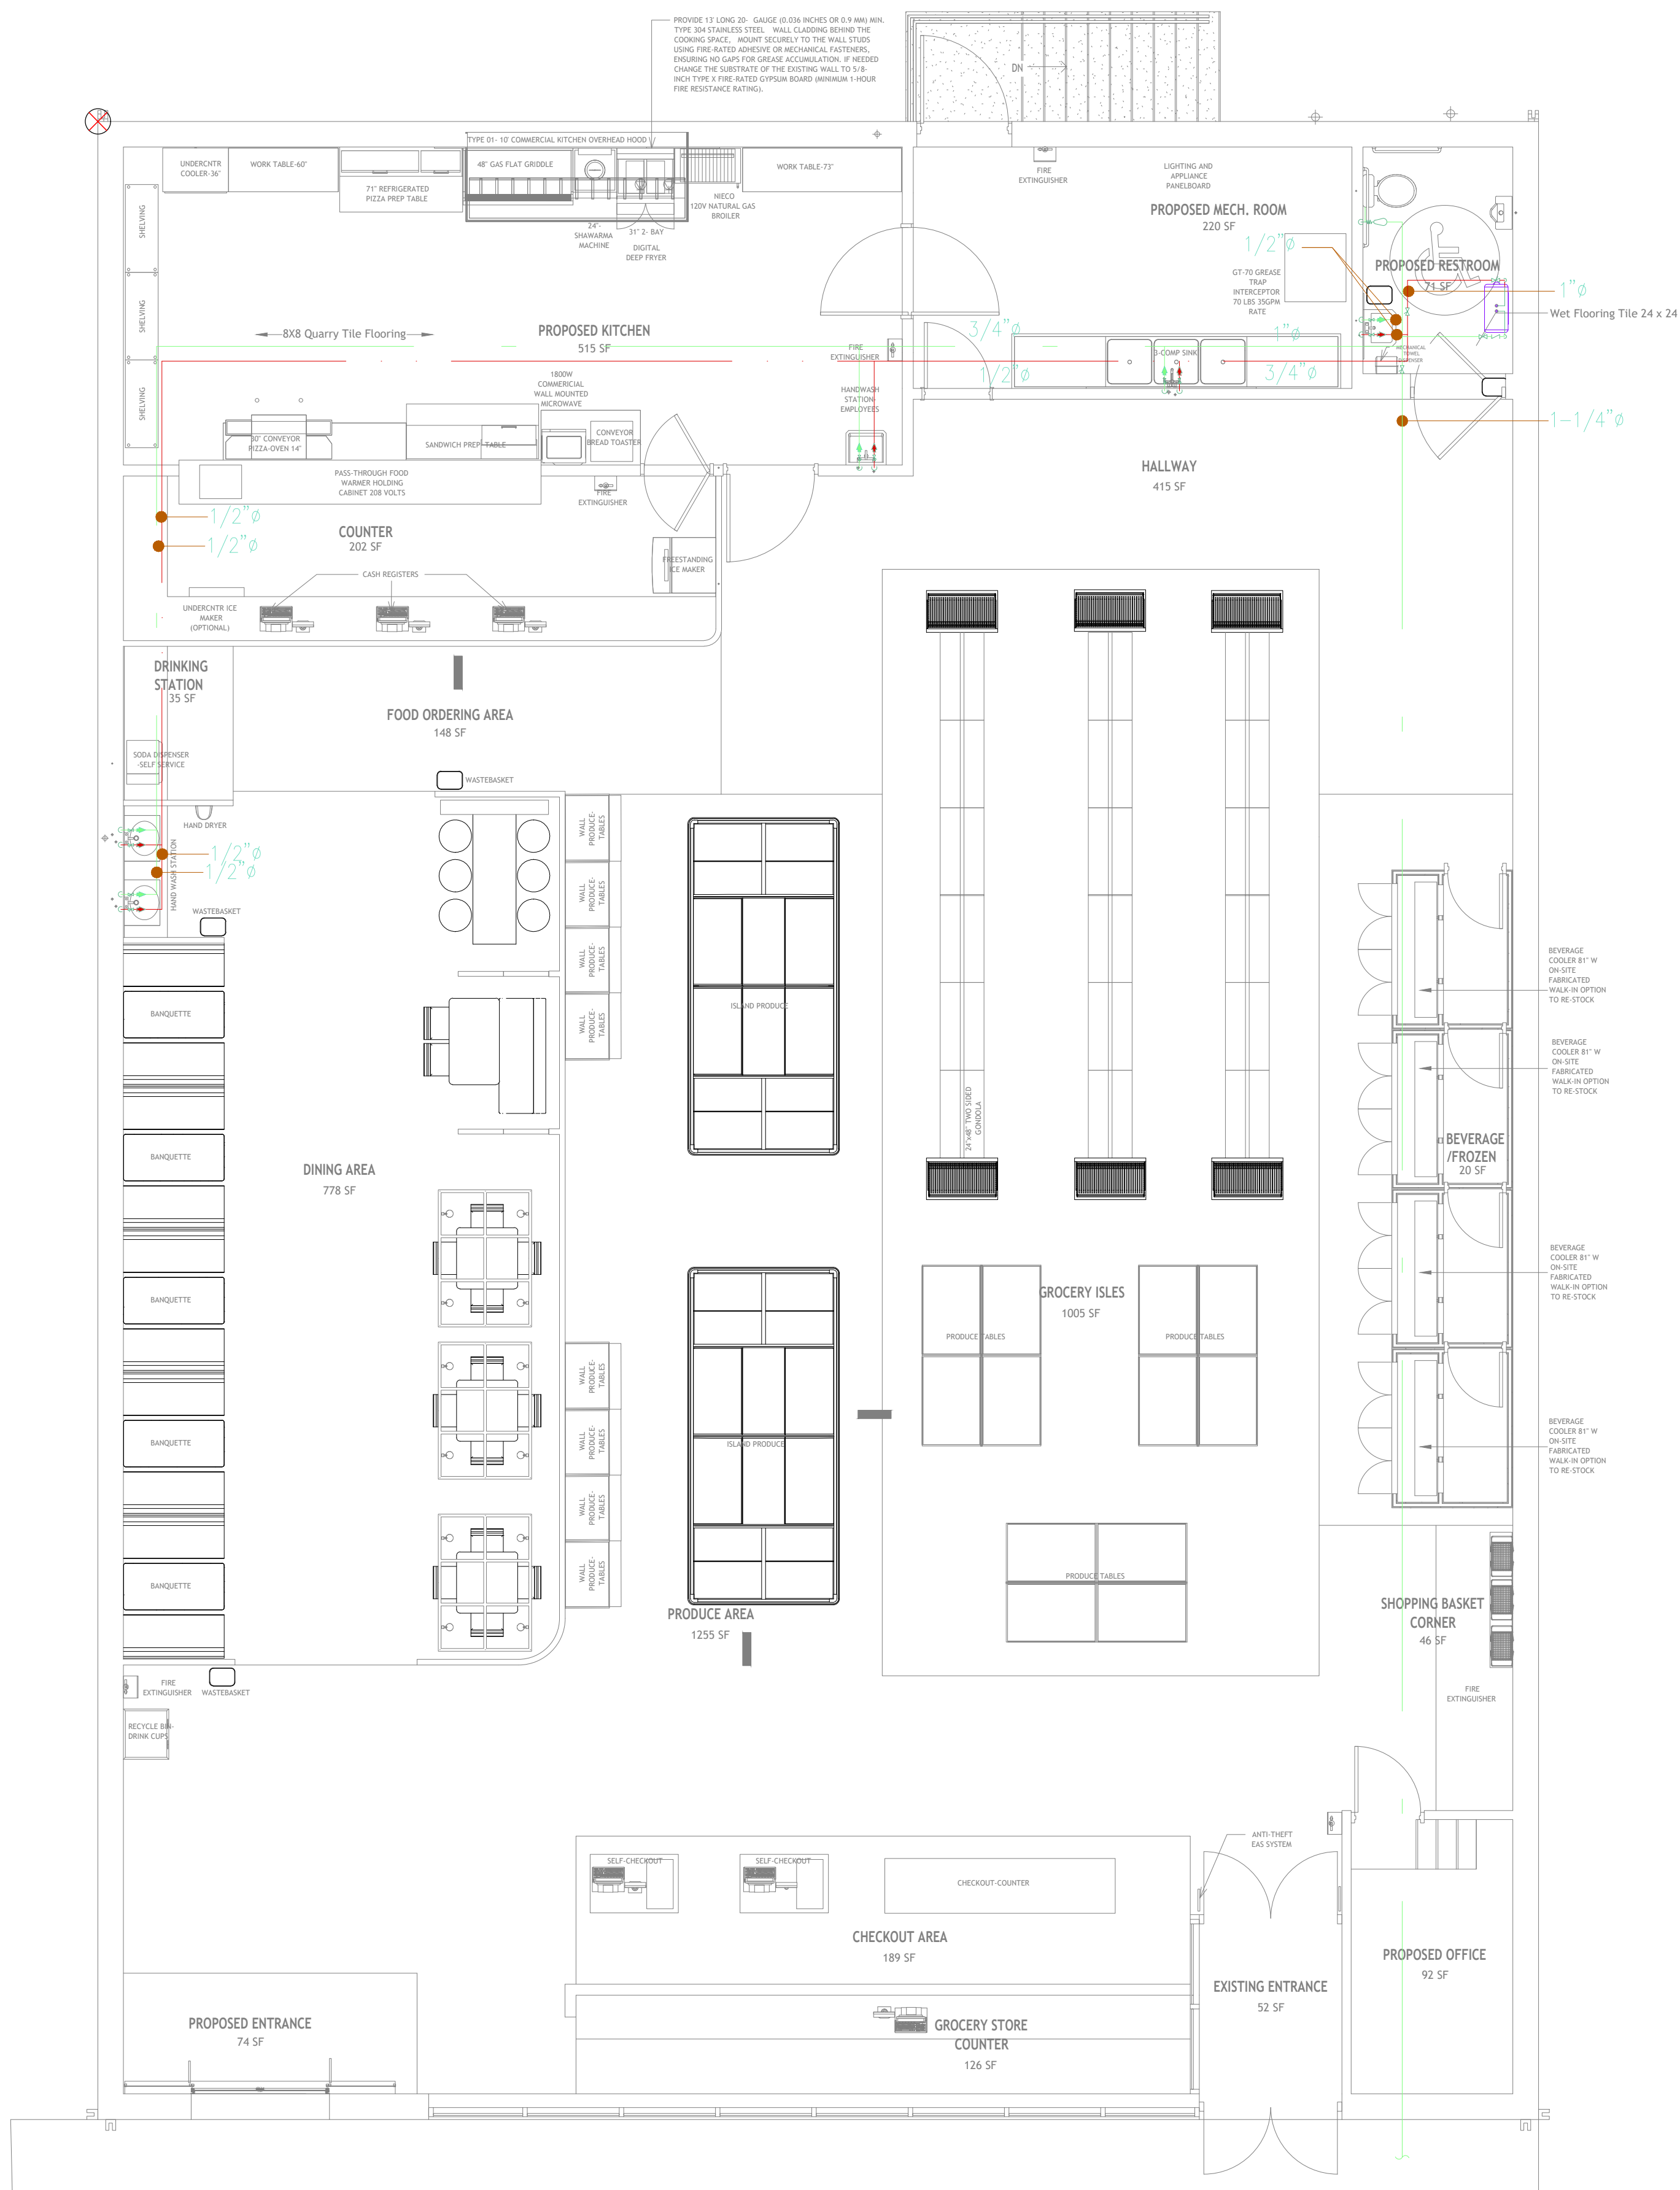

ABBREVIATIONS


FD FLOOR DRAIN
COP CLEAN OUT PLUG
MH MANHOLE

PLUMBING LEGEND

SYMBOL	DESCRIPTION
	WASTE PIPE
	SOIL PIPE
	WASTE PIPE (BURIED)
	PIPE UP
	WASTE PIPE BREAK
	SOIL PIPE BREAK
	CLEAN OUT PLUG
	FLOOR CLEAN OUT
	SITE MAN HOLE
	COLD WATER
	HOT WATER



DESCRIPTION		REVISION NO.	DATE
ADVANCE COPY			
PROJECT:			
GREENE GROCERY AND CAFE202 NORTH MAIN STREET GREENSBRO GA 30642			
OWNER NAME:			
FIROZALI MOMIN			
CONSULTANTS:			
TITLE:			
WATER SUPPLY LAYOUT			
DESIGNED BY	SCALE	DATE	
I.M	3/32"=1'-0"	MAY-2025	
DRAWN BY	JOB NO.	DRAWING NO.	
I.M	01	WS-01	
CHECKED BY	ORIGINAL SHT SIZE:	PLOTTED SHT SIZE:	
-	A3	A3	
APPROVED BY	CAD FILE NAME:		
-	LIGHTING-4.dwg		

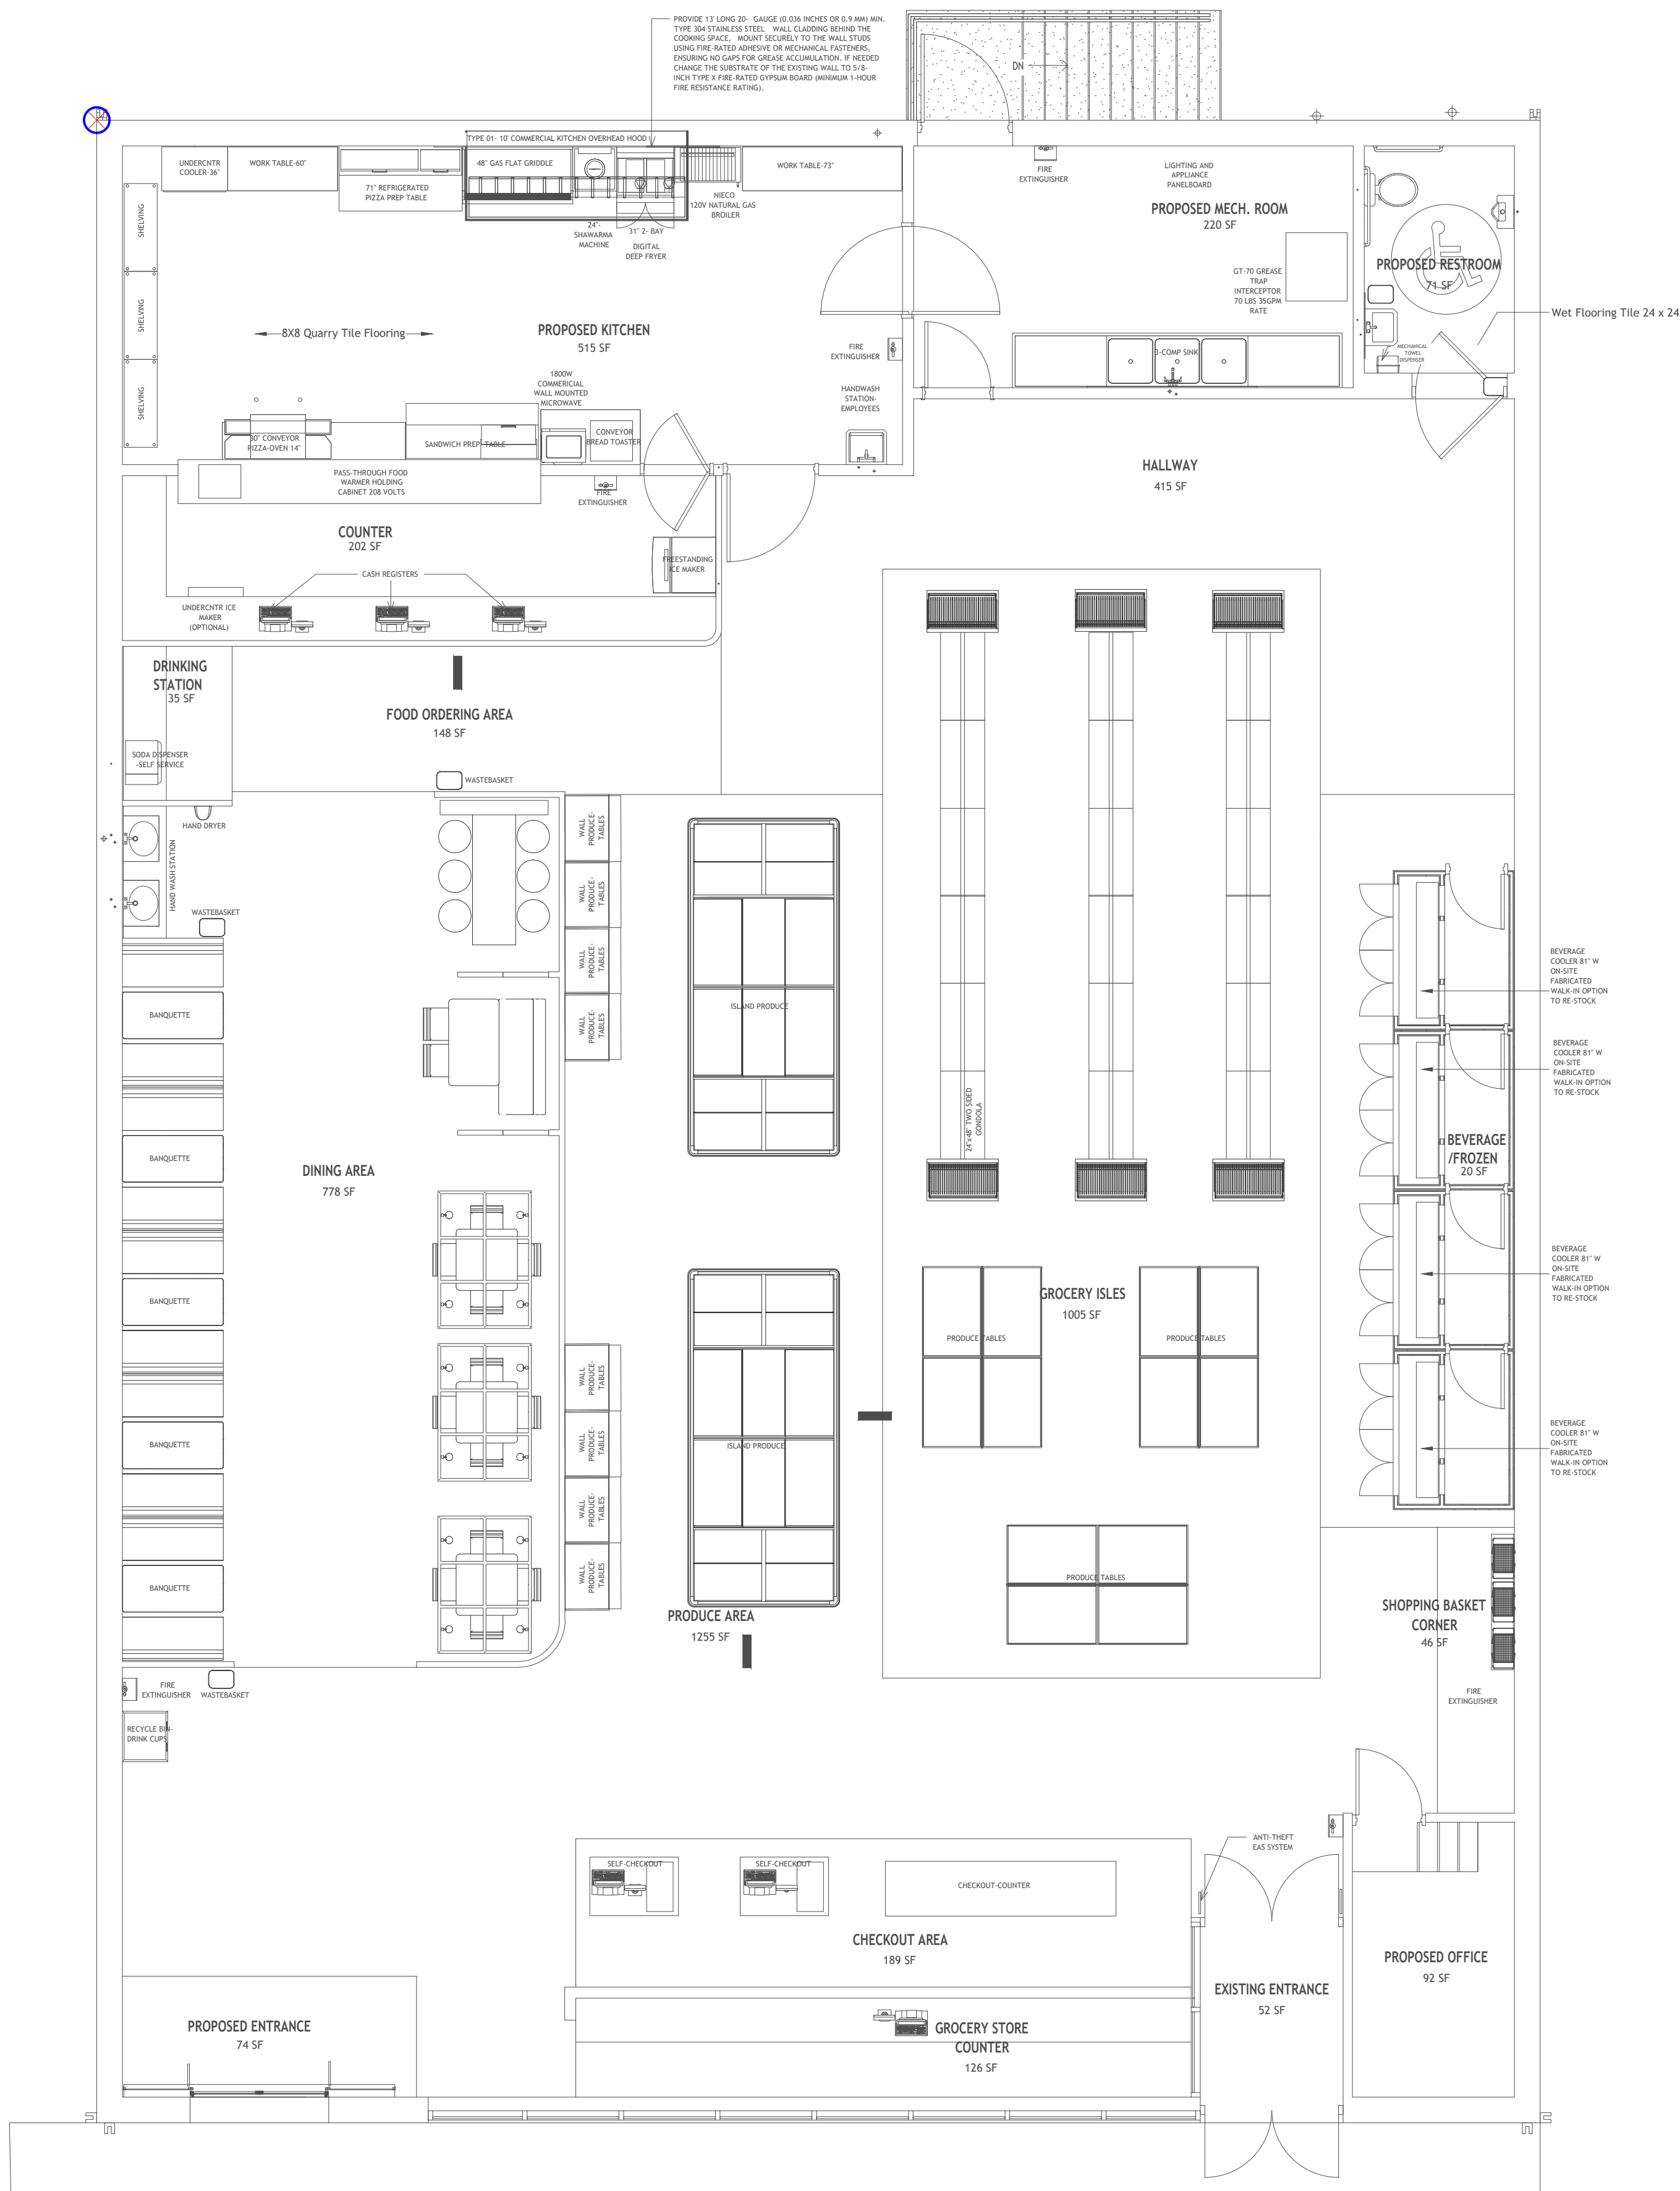

DESCRIPTION	REVISION NO. DATE
ADVANCE COPY	

PROJECT:

GREENE GROCERY AND CAFE202 NORTH MAIN
STREET GREENSBRO GA 30642

OWNER NAME:

FIROZALI MOMIN

CONSULTANTS:

TITLE:

ARCHITECHTURE LAYOUT

DESIGNED BY I.M	SCALE 3/32"=1'-0"	DATE MAY-2025
DRAWN BY I.M	JOB NO. 01	DRAWING NO. AR-01
CHECKED BY -	ORIGINAL SHT SIZE: A3	PLOTTED SHT SIZE: A3
APPROVED BY -	CAD FILE NAME: LIGHTING-4.dwg	